


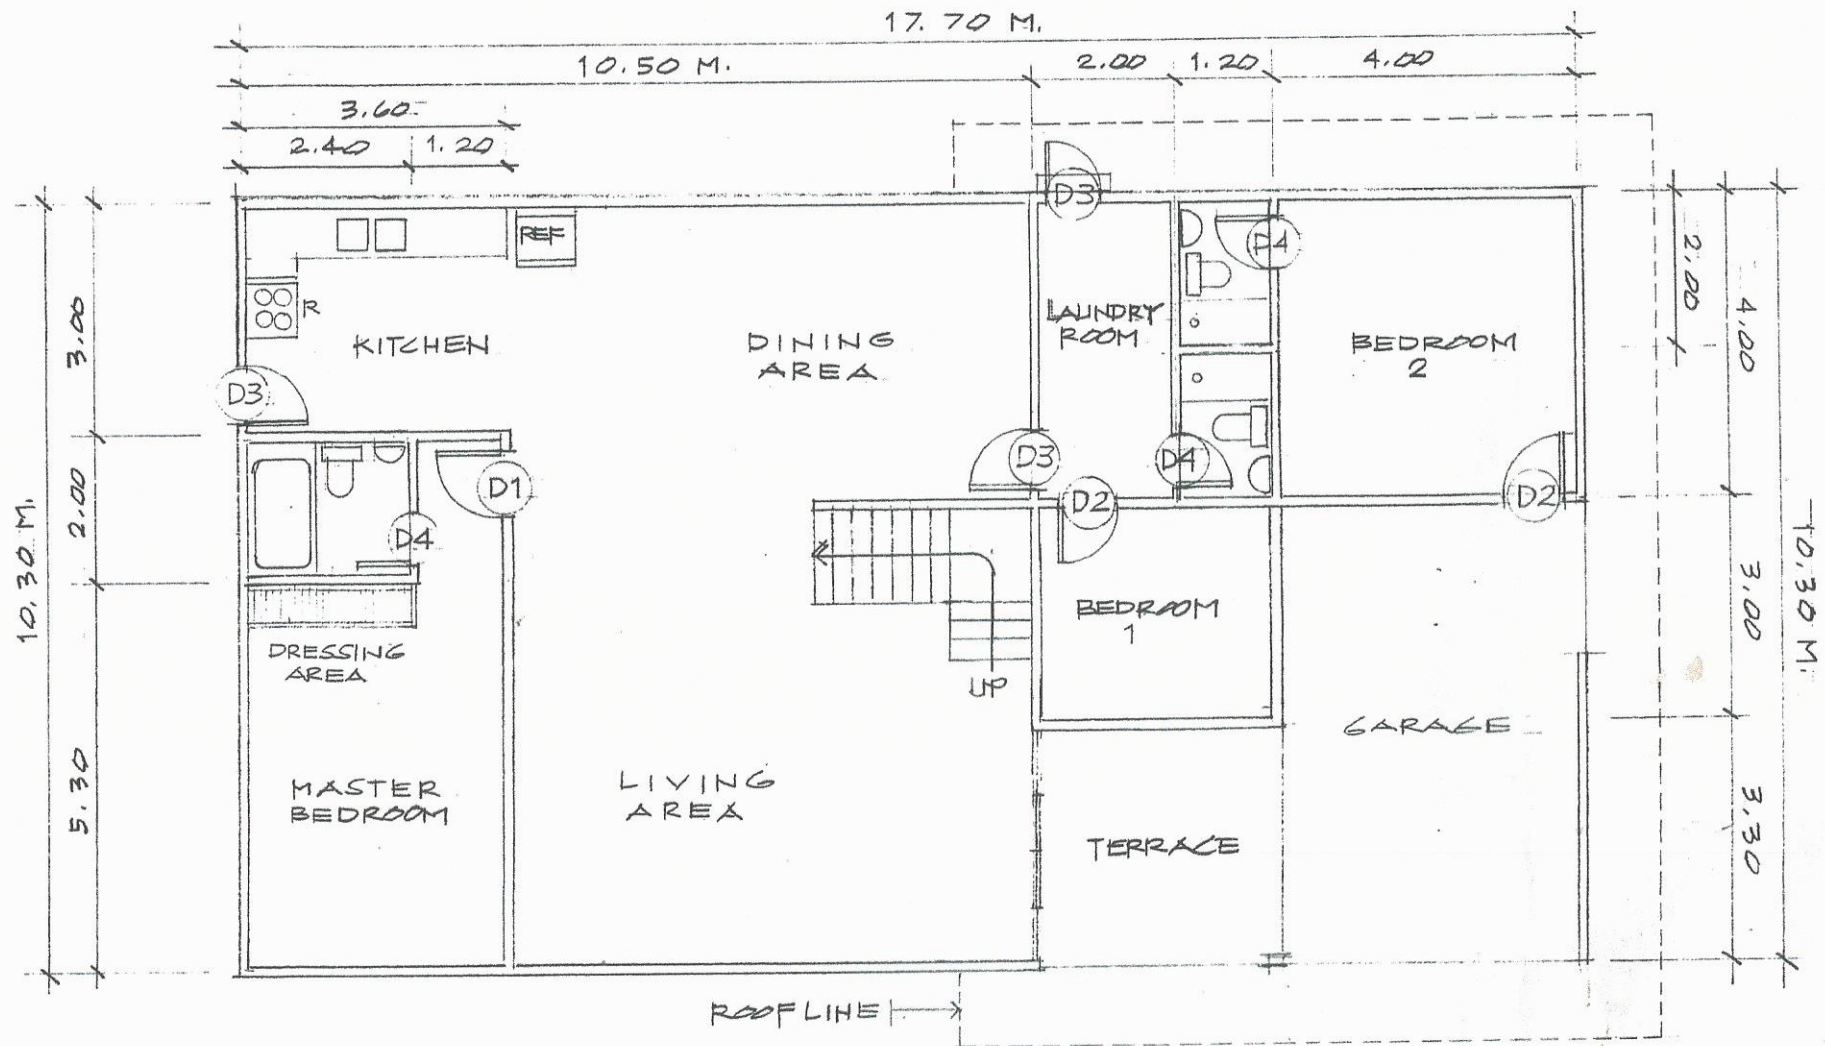


PROPOSED GROUND FLOOR PLAN

SCALE:

1:100 M.




AGENCY	DRAWN BY:	END USER:	ENDORSED BY:	PROJECT TITLE:	REC. APPROVAL:	APPROVED BY:	SHEET NO.	
CVSU	 A. LLAMADO PPS STAFF	 G. DESENGANO DIR. OBA	 D. R. ESCANO DIR. PPS	REPAIR AND IMPV'T. OF WHITE HOUSE	 C. A. POLINGA V.PASS	 H. DAROBLES PRESIDENT	A	1 13

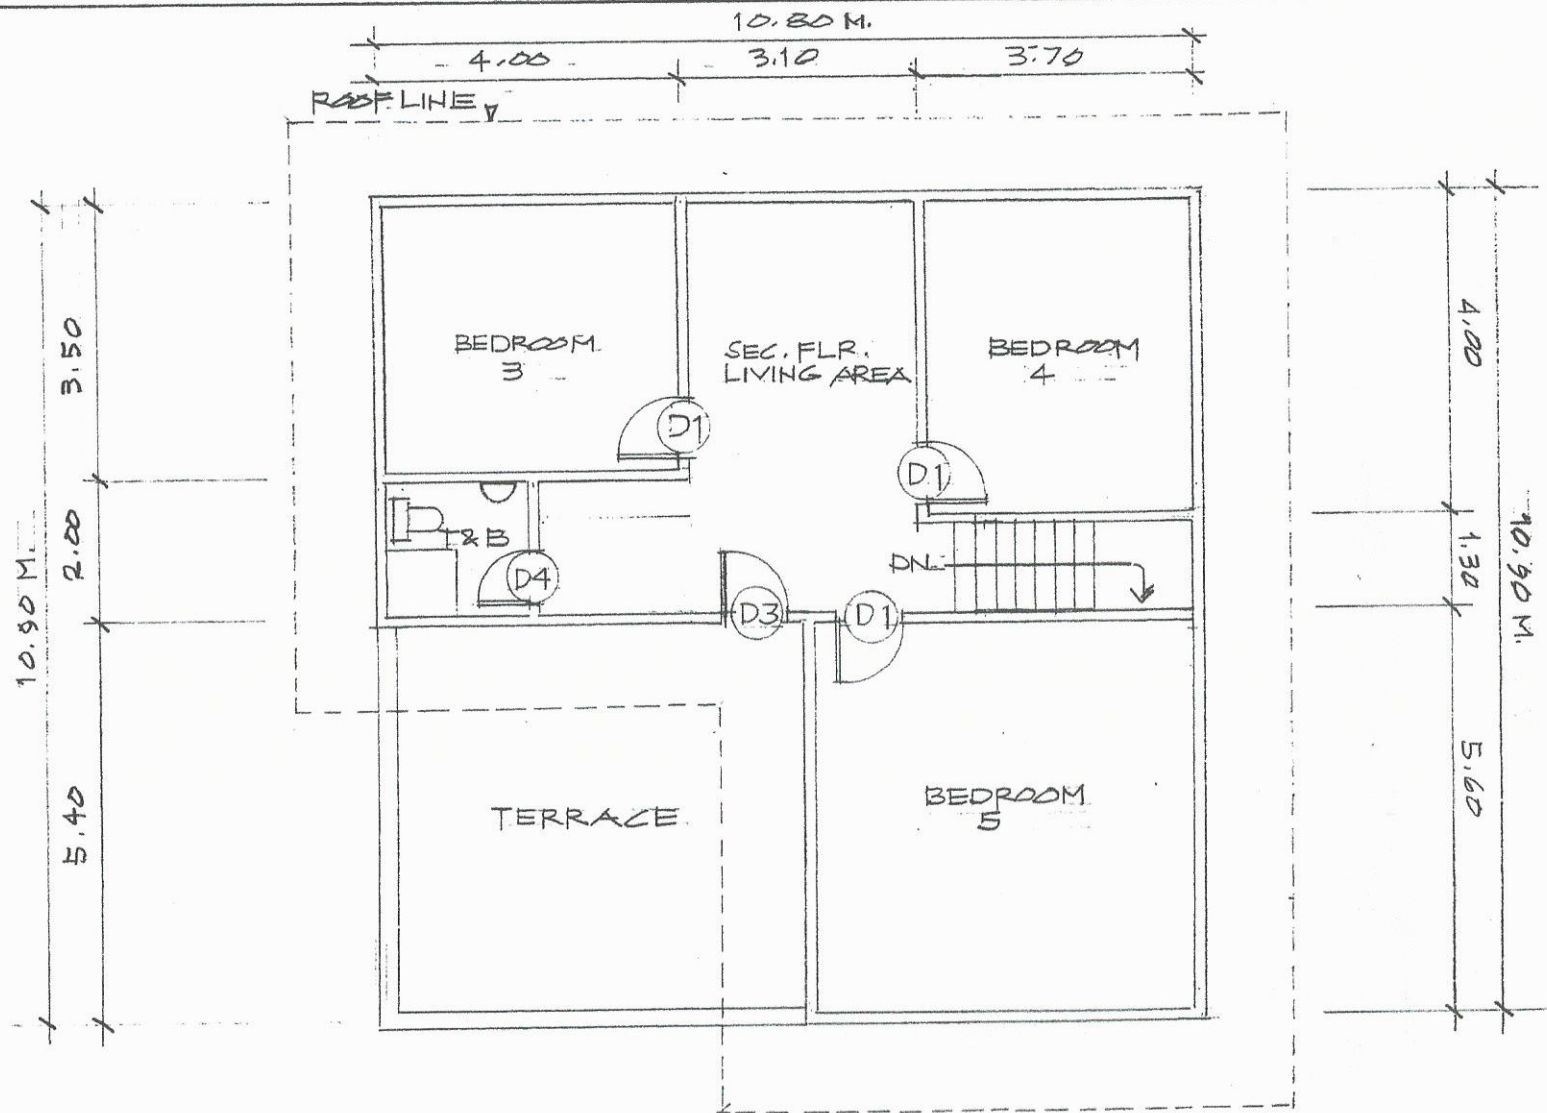


PROPOSED SECOND FLOOR PLAN

SCALE:

   1:100 M.

AGENCY	DRAWN BY:	END USER:	ENDORSED BY:	PROJECT TITLE:	REC. APPROVAL:	APPROVED BY:	SHEET NO.	
CVSU				REPAIR & IMPV'T. OF WHITE HOUSE			A.	2
	PPS STAFF	DIR. OBA	DIR. PPS					13

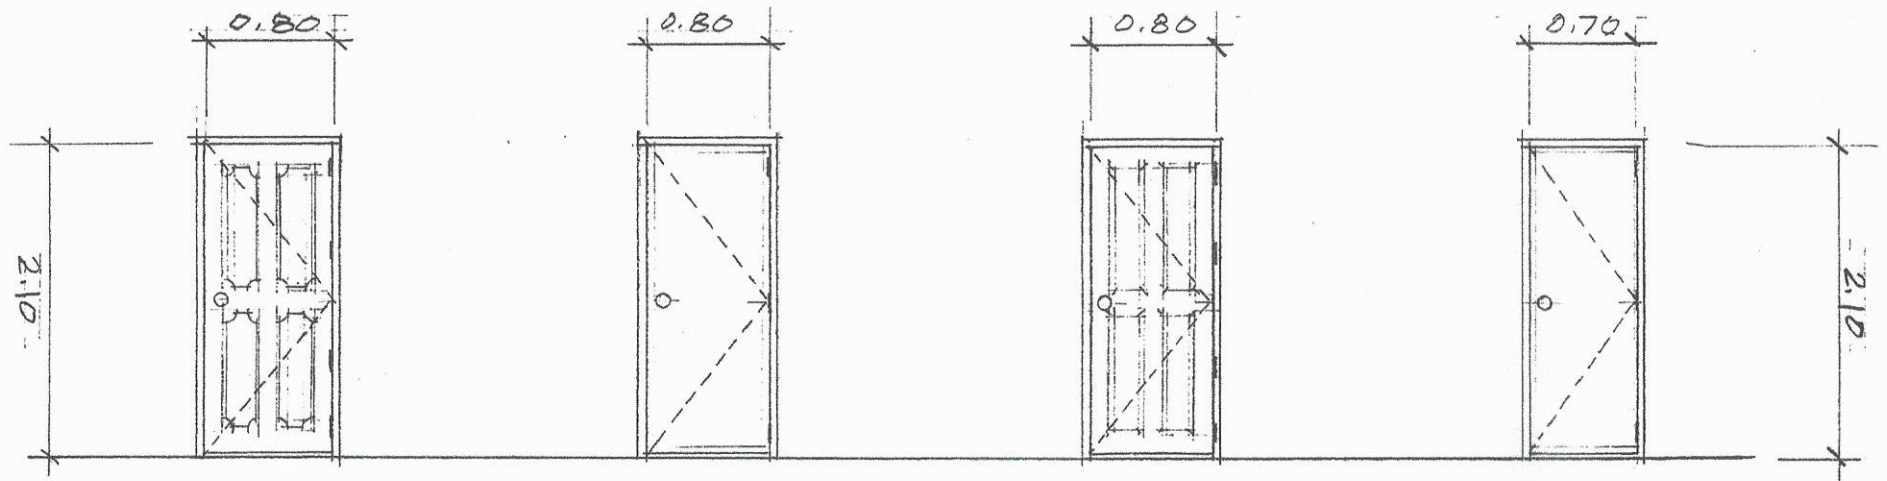

FOUR (4) SETS

FLUSH DOOR TYPE
ON A 2X4 DOOR JAMB
W/ COMPLETE ALL.

TWO (2) SETS

PANEL DOOR TYPE
ON A 2X4 DOOR JAMB
W/ COMPLETE ALL.

FOUR (4) SETS

FLUSH DOOR TYPE
ON A 2X4 DOOR JAMB
W/ COMPLETE ALL.


FOUR (4) SETS

SCHEDULE OF DOORS AT GROUND & SEC. FLOOR


SCALE:

1:100 M.


AGENCY	DRAWN BY:	END USER:	ENDORSED BY:	PROJECT TITLE:	REC. APPROVAL:	APPROVED BY:	SHEET NO.
CYSU	 A. LLAMADO FPS STAFF	 G. DESENGAÑO DIR. OBA	 D. RESCANO DIR. FPS	REPAIR & IMPV'T. OF WHITE HOUSE	 E. A. POLINGA PASS	 H. D. ROBLES RESIDENT	A 3 13

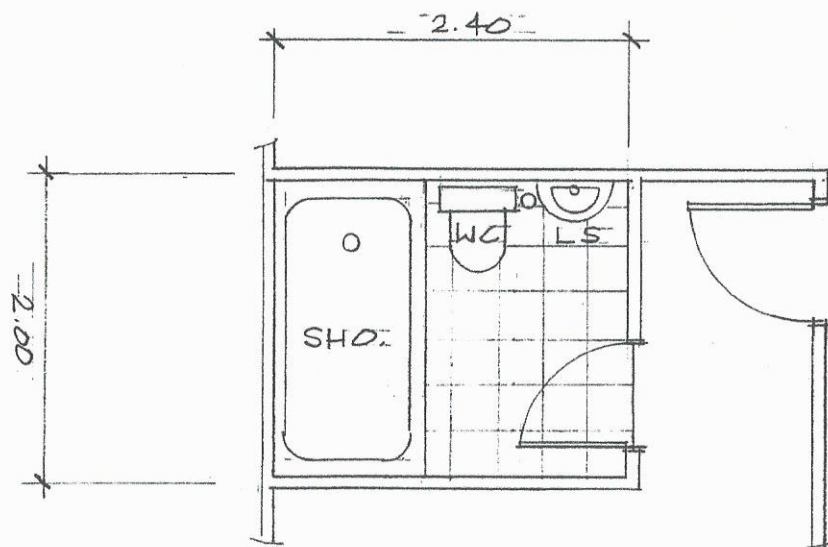

CR (MASTER BEDROOM)

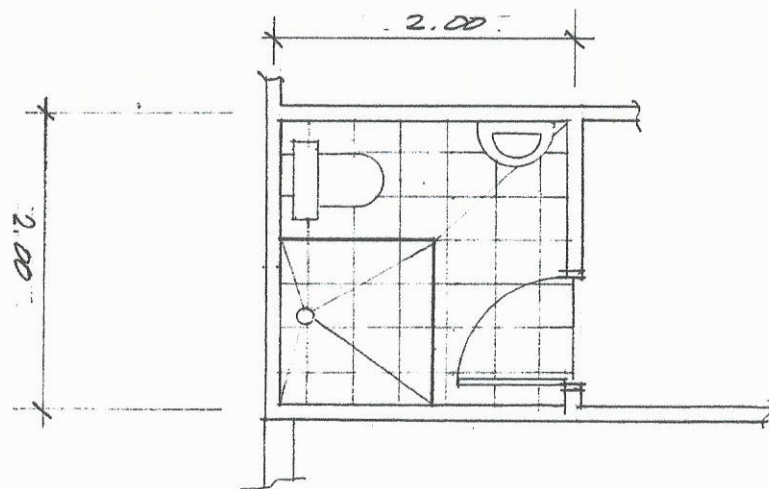


CR (SECOND FLOOR)

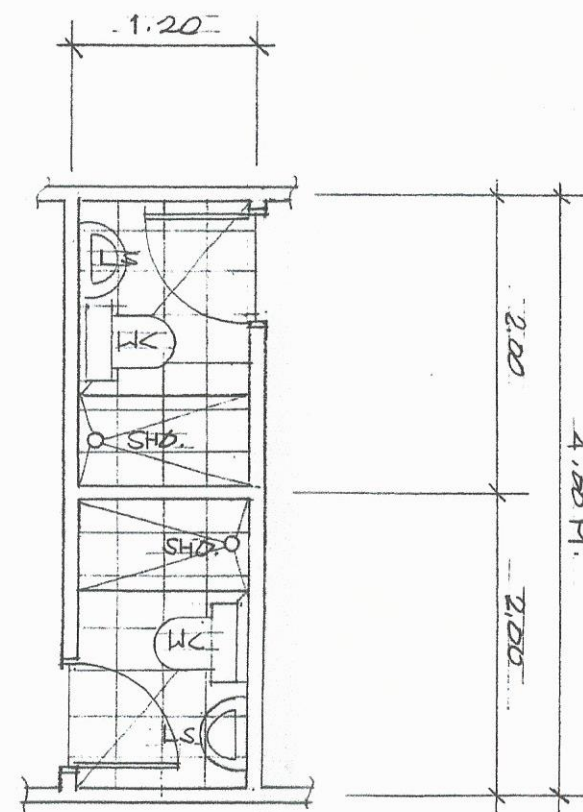

CR (LAUNDRY/BEDROOM-2)

SCALE: 1:50 MTRS


AGENCY	DRAWN BY:	END USER:	ENDORSED BY:	PROJECT TITLE:	REC. APPROVAL:	APPROVED BY:	SHEET NO.
CYSU	 A. LLAMADO PTS STAFF	 G. DESENGANO DIR. OBA	 D. R. ESCANO DIR. PPS	REPAIR & IMPV'T. OF WHITE HOUSE	 E. A. POLINGA VPASS	 H. D. ROBLES PRESIDENT	A 4 13

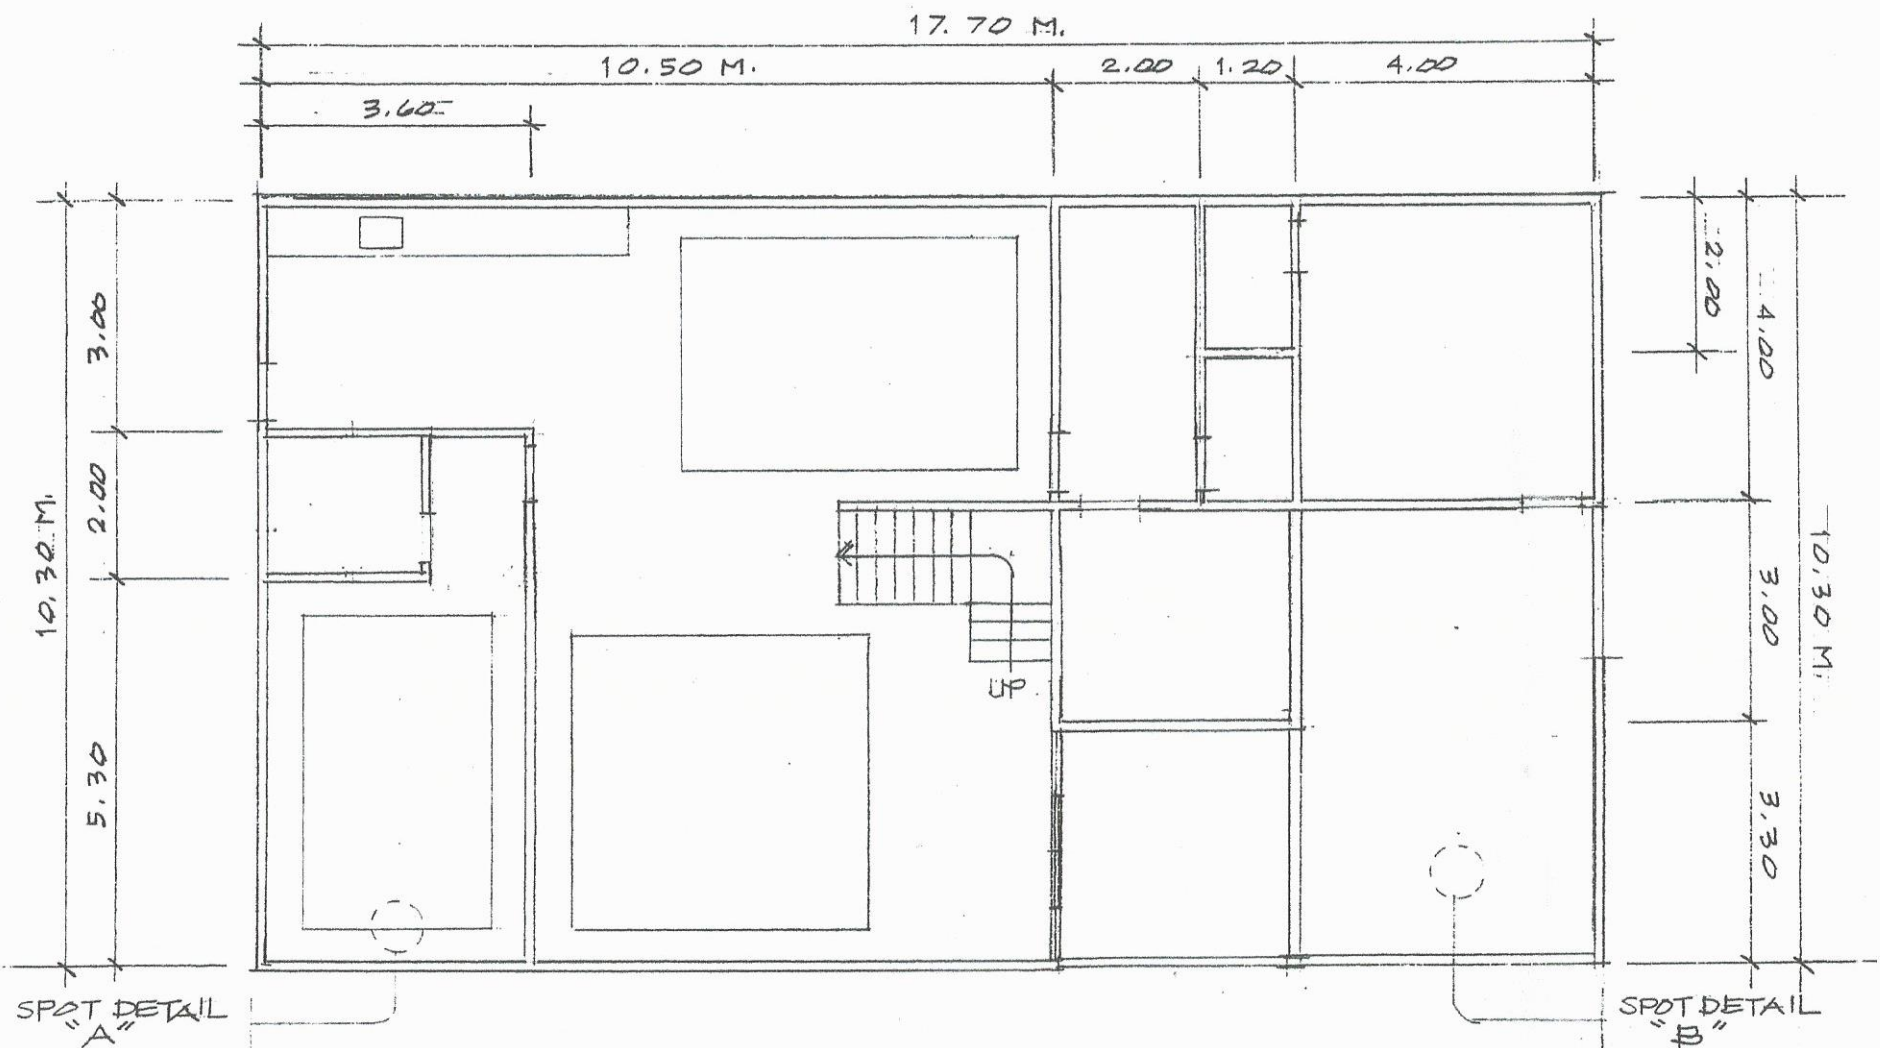


GROUND FLOOR CEILING PLAN

SCALE:

 1:100 M.


AGENCY	DRAWN BY:	END USER:	ENDORSED BY:	PROJECT TITLE:	REC. APPROVAL:	APPROVED BY:	SHEET NO.
CVSU	 A. LLAMADO PPS STAFF	 G. DESENGANO DIR. OBA	 D. RESCANO DIR. PPS	REPAIR AND IMPV'T. OF WHITE HOUSE	 C. A. BODINGA VPASS	 H. D. REYES PRESIDENT	S 5 13

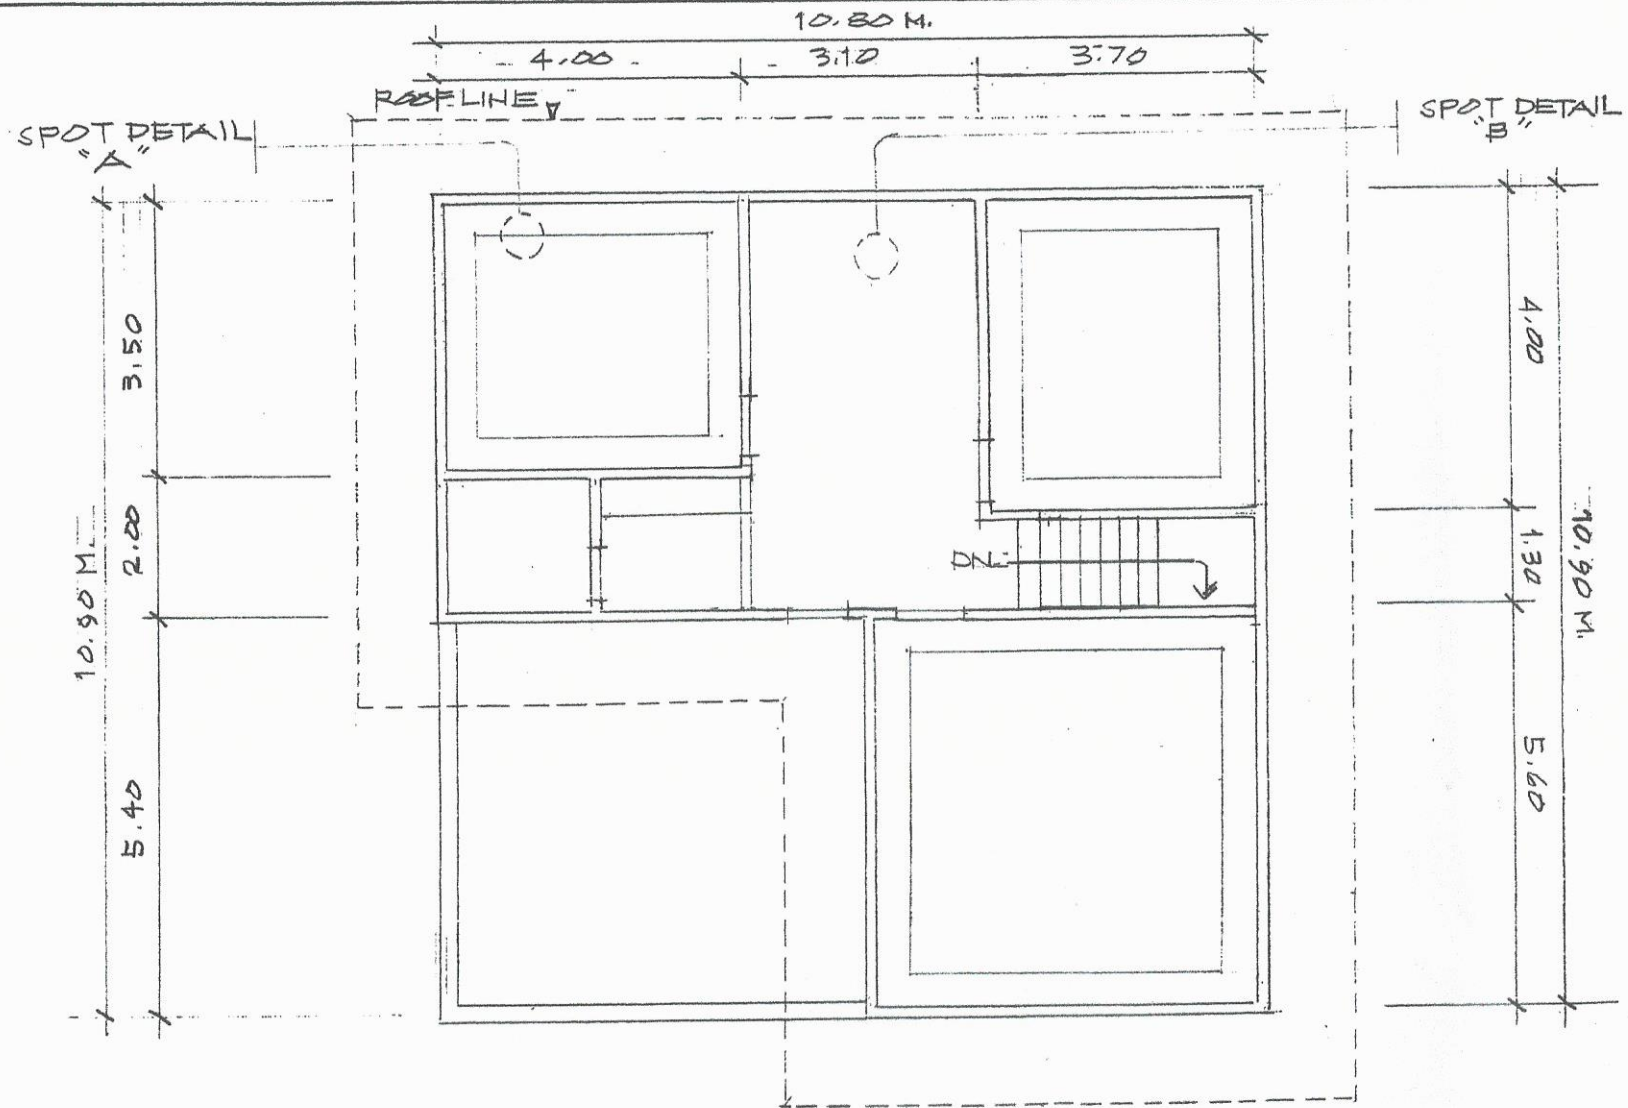


SECOND FLOOR CEILING PLAN

SCALE:

 1:100 MAN

AGENCY	DRAWN BY	END USER	ENDORSED BY	PROJECT TITLE	REC. APPROVAL	APPROVED BY	SHEET NO.
CVSU	 A. LLAMADO PPS STAFF	 G. DESENGAÑO DIR. OBA	 D. R. ESCANO DIR. PPS	REPAIR & IMPV'T. OF WHITE HOUSE	 E. AFOLINGA VRASS	 H. D. ROALES RESIDENT	6 13

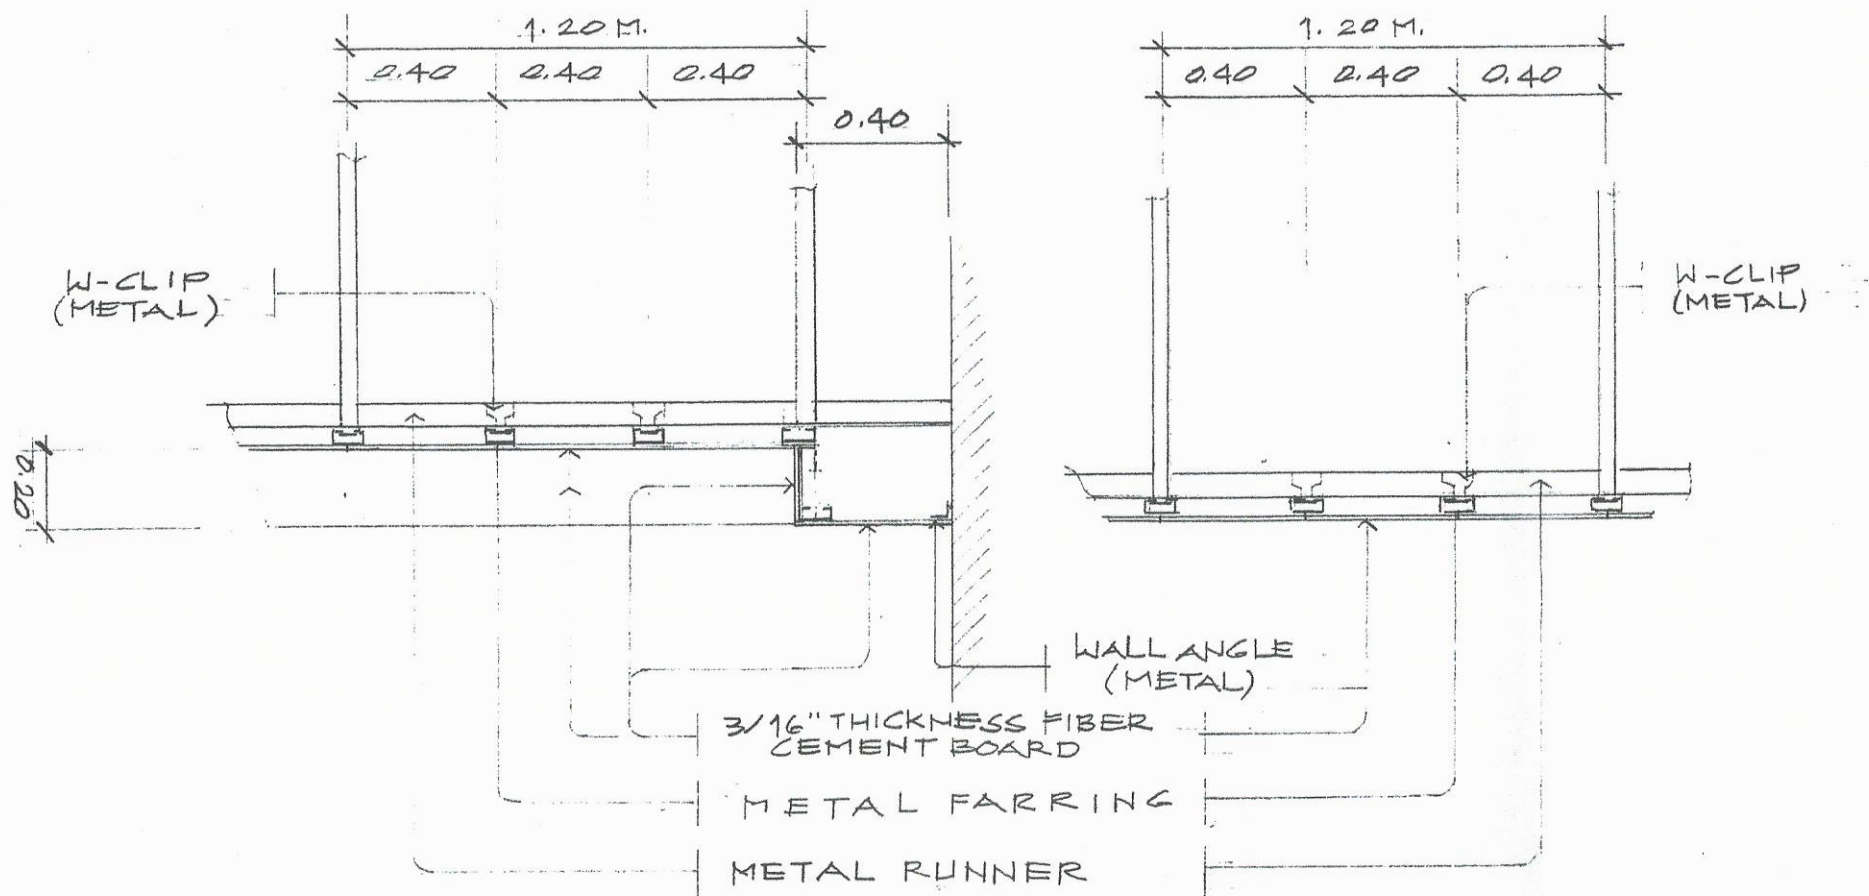


SPOT DETAIL "A"

SCALE: 1:20 M.

SPOT DETAIL "B"

SCALE: 1:20 M.

AGENCY	DRAWN BY:	END USER:	ENDORSED BY:	PROJECT TITLE:	REC. APPROVAL:	APPROVED BY:	SHEET NO.
CYSU	<i>A.L. LLANADO</i> A.L. LLANADO PPS STAFF	<i>G. DESENGAÑO</i> G. DESENGAÑO DIR. OBA	<i>D.R. ESCAÑO</i> D.R. ESCAÑO DIR. PPS	REPAIR & IMPV'T. OF WHITE HOUSE	<i>C.A. BOLINGA</i> C.A. BOLINGA PASS	<i>H.D. ROBLES</i> H.D. ROBLES PRESIDENT	S 7 13

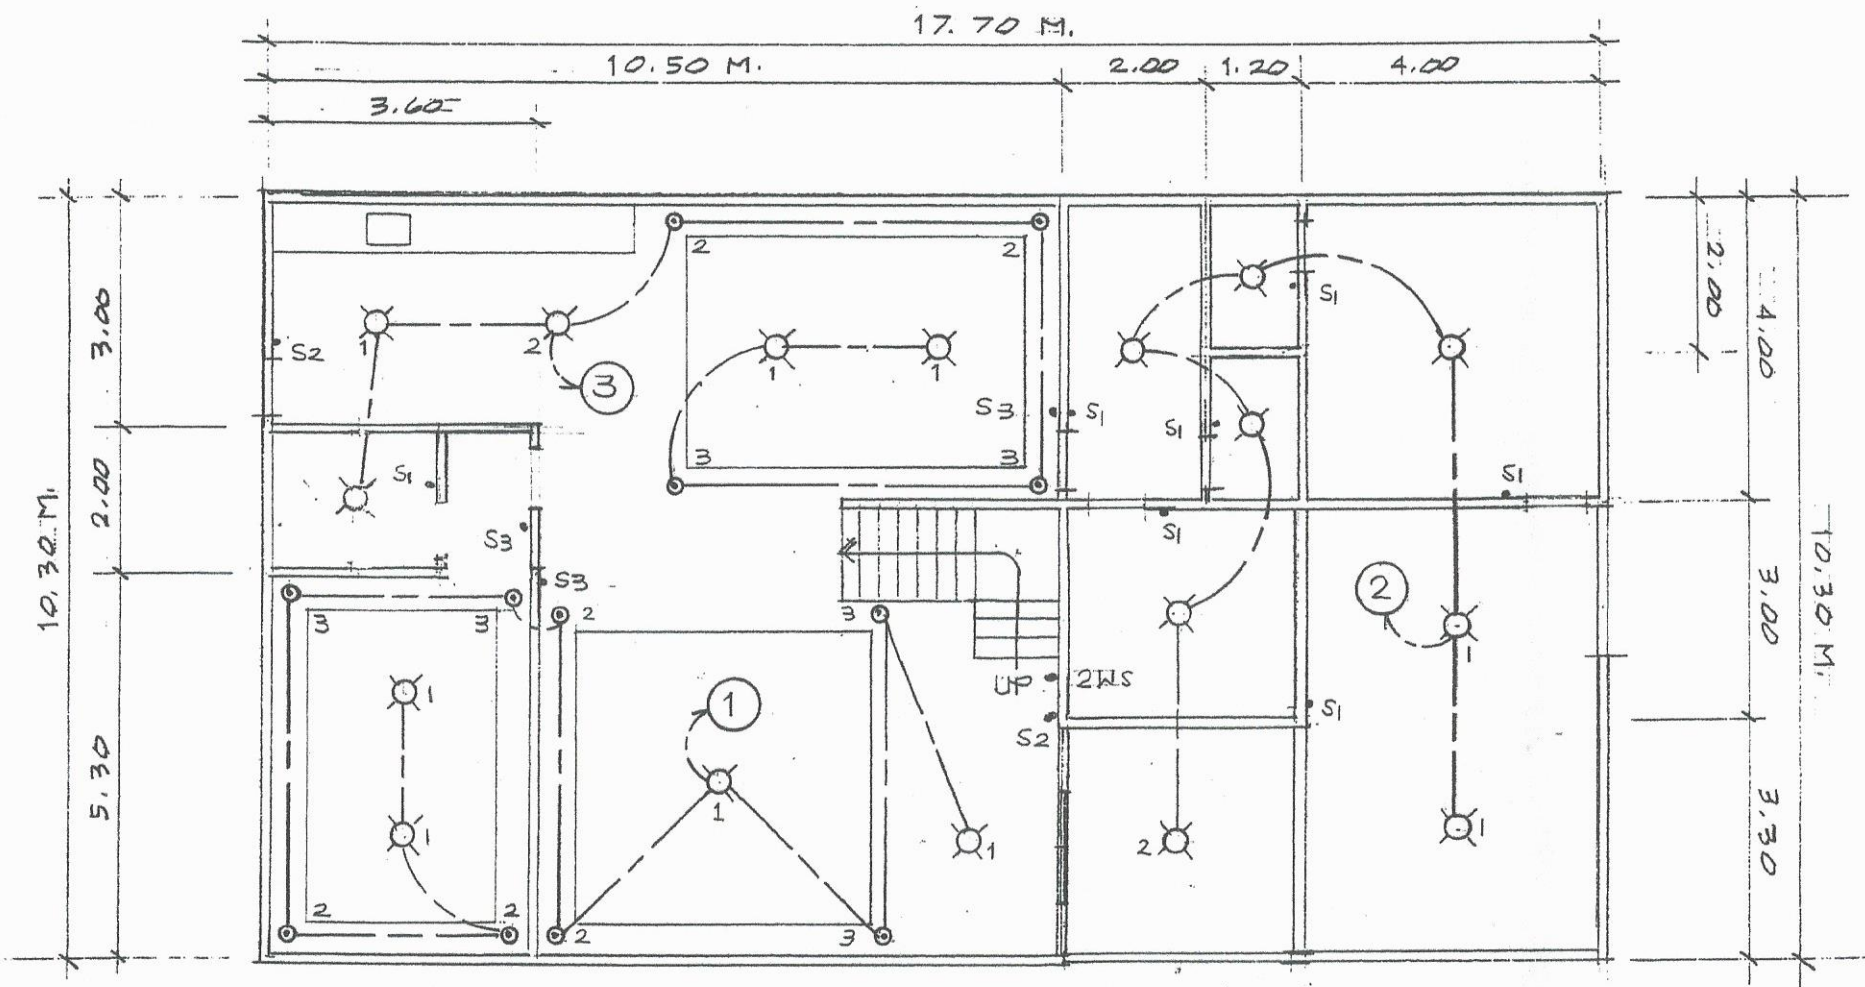


GROUND FLOOR LIGHTING LAYOUT

SCALE:

1:100 M.

AGENCY	DRAWN BY:	END USER:	ENDORSED BY:	PROJECT TITLE:	REC. APPROVAL:	APPROVED BY:	SHEET NO.
CVSU	<i>[Signature]</i> A.L. LLAMADO PPS STAFF	<i>[Signature]</i> G. DE SENGANO DIR. OBA	<i>[Signature]</i> D. RESCANO DIR. PPS	REPAIR AND IMPV'T. OF WHITE HOUSE	<i>[Signature]</i> C. A. BOLINGA VPASS	<i>[Signature]</i> H. P. ROBLES PRESIDENT	8 13

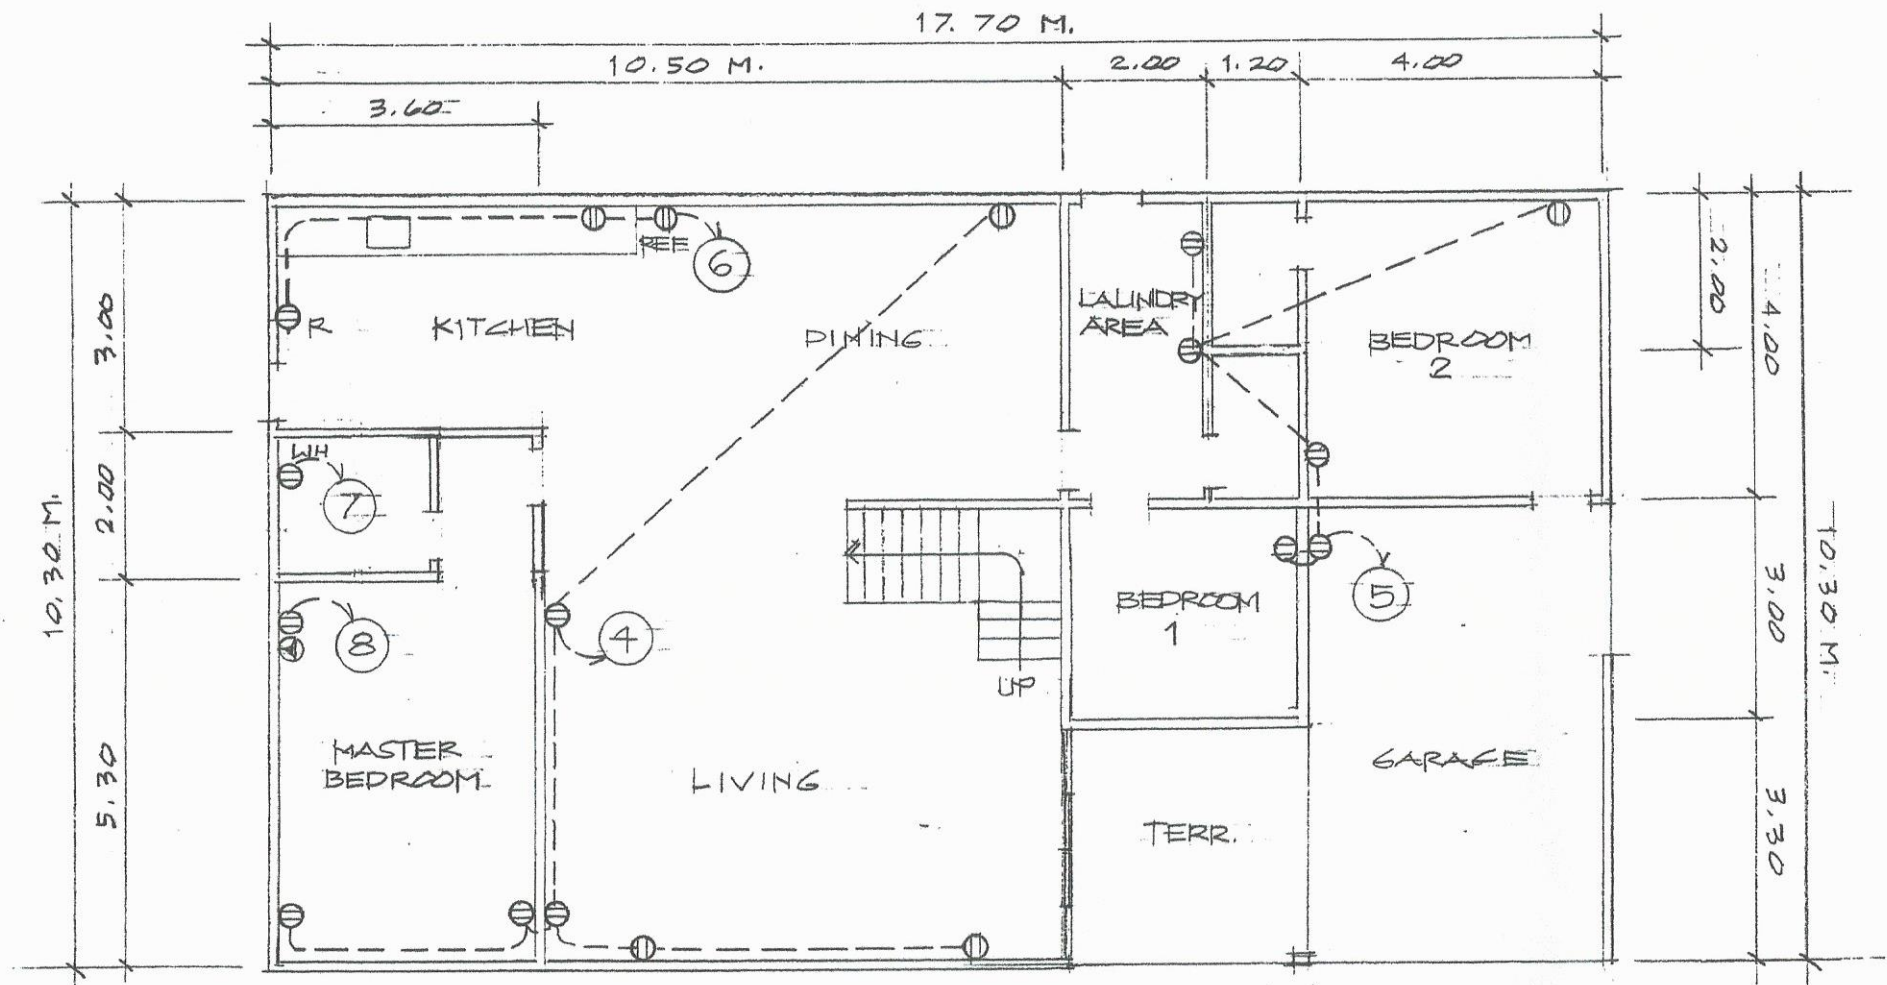


GROUND FLOOR CONV. OUTLET LAYOUT

SCALE:

1: 100 M.

AGENCY	DRAWN BY:	END USER:	ENDORSED BY:	PROJECT TITLE:	REC. APPROVAL:	APPROVED BY:	SHEET NO.	
CVSU	<u>A. L. LAMADO</u> PPS STAFF	<u>G. DESENGAÑO</u> DIR. OBA	<u>D. R. ESCAÑO</u> DIR. PPS	REPAIR AND IMPV'T. OF WHITE HOUSE	<u>C. A. POLINGA</u> VPASS	<u>H. D. ROBLES</u> PRESIDENT	E	9 13

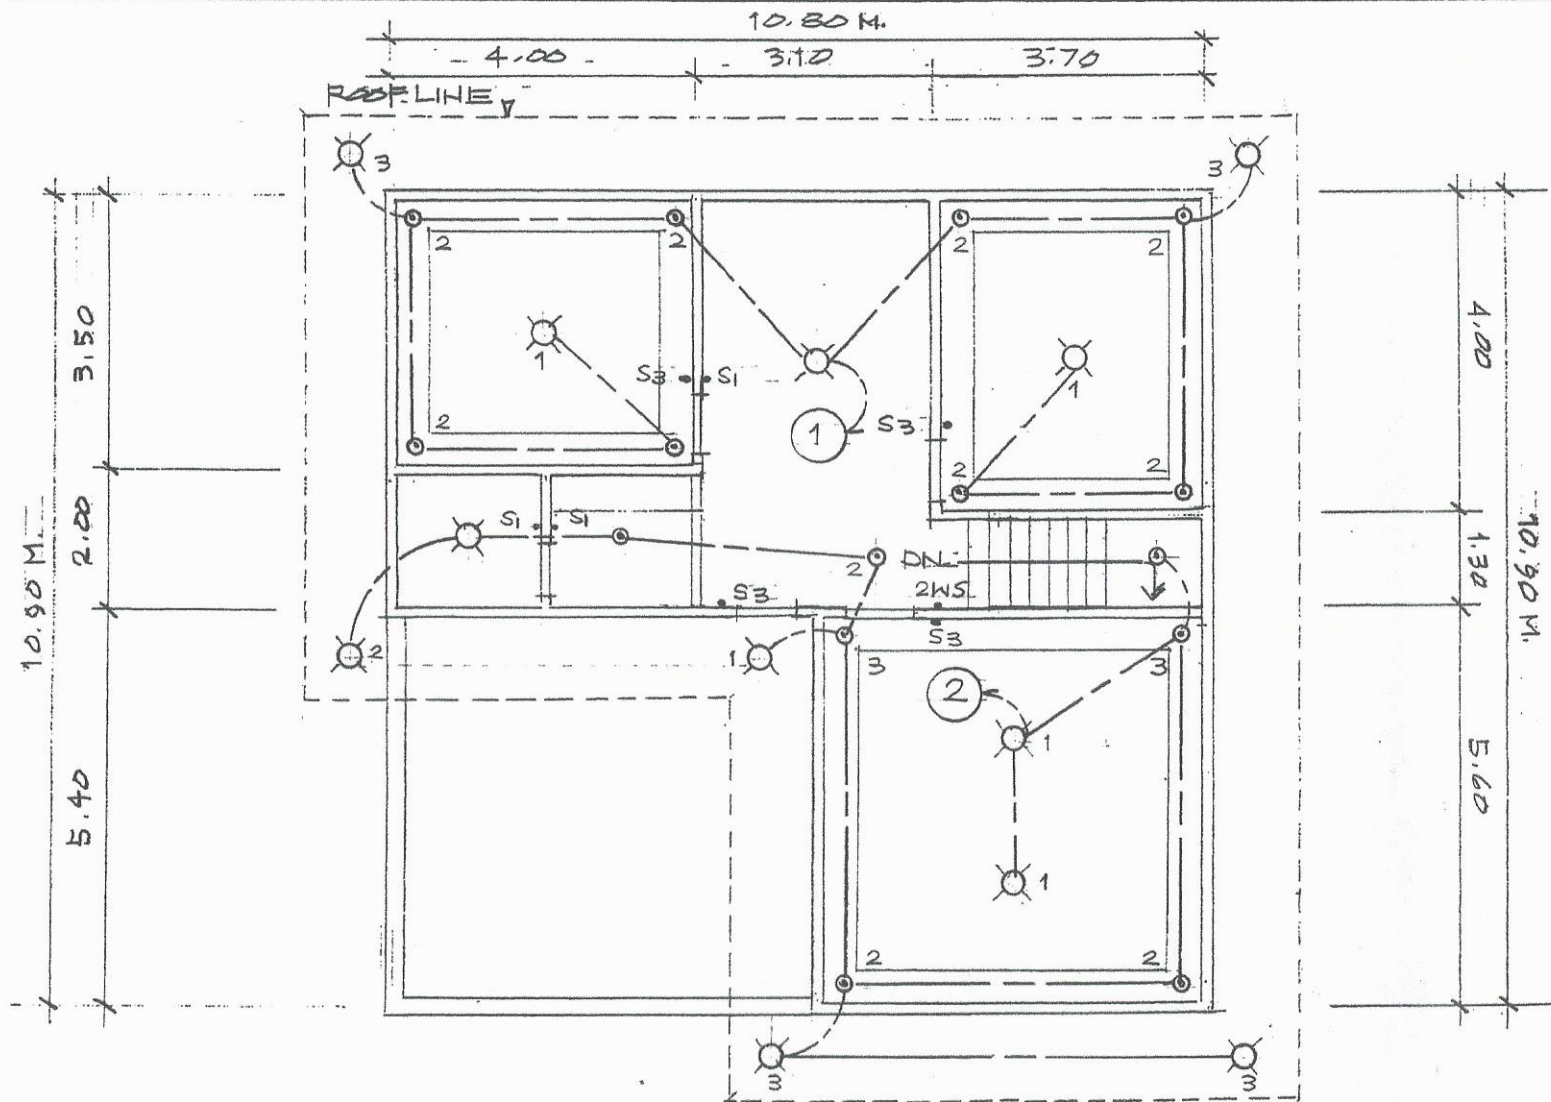


SECOND FLOOR LIGHTING LAYOUT

SCALE:

1:100 M.

AGENCY	DRAWN BY:	END USER:	ENDORSED BY:	PROJECT TITLE:	REC. APPROVAL:	APPROVED BY:	SHEET NO.
CVSU	 A.L. LLAMADO PPS STAFF	 G. DESENGANO DIR, OBA	 D.R. ESCANO DIR, PPS	REPAIR & IMPV'T. OF WHITE HOUSE	 E. APOLINGA VPASS	 H.D. ROBLES PRESIDENT	E. 10. 13.

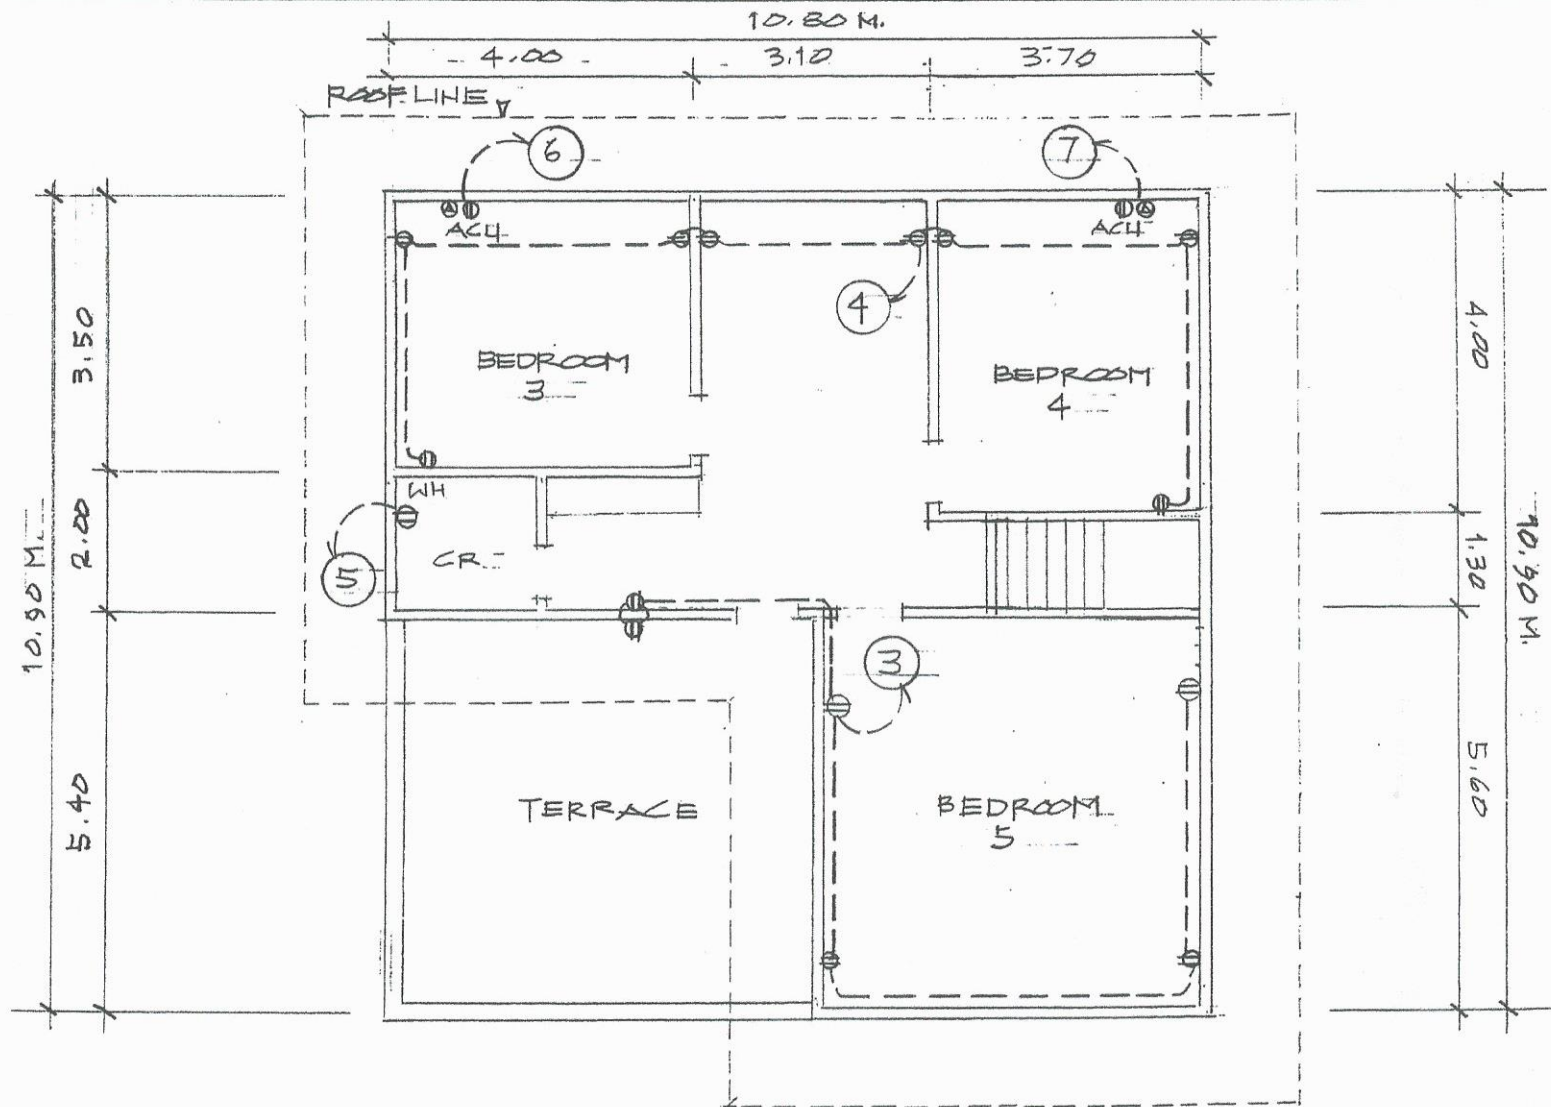


SECOND FLOOR CONV. OUTLET LAYOUT

SCALE:

1:100 M.


AGENCY	DRAWN BY:	END USER:	ENDORSED BY:	PROJECT TITLE:	REC. APPROVAL:	APPROVED BY:	SHEET NO.
CVSU	 A.L. LLAMADO PPS STAFF	 G. DESENGAÑO DIR. OBA	 D.R. ESCAÑO DIR. PPS	REPAIR & IMPV'T. OF WHITE HOUSE		 H.P. ROBLES PRESIDENT	E. 11. 13.

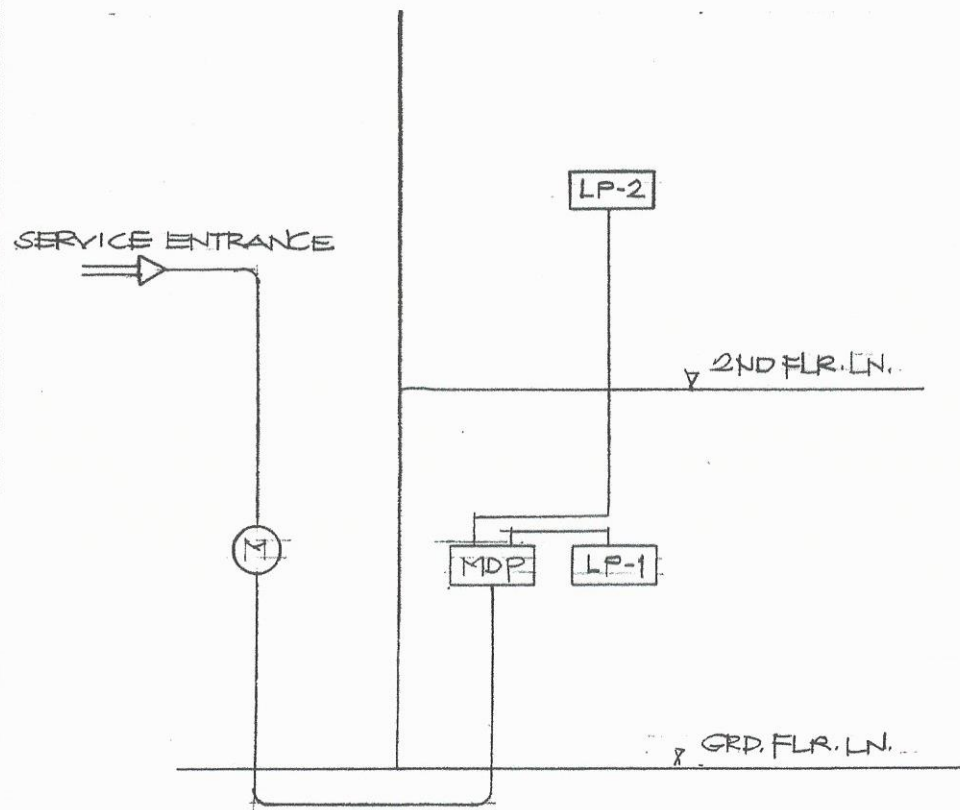


RISER DIAGRAM


LEGEND:

 - ⊗ LIGHTING (FLOURESCENT OR LED)
- ⊙ PIN LIGHT
- ⊖ CONVENIENCE OUTLET (DOUBLE)
- ⊖_{WH} CONV. OUTLET (WATER HEATER)
- ⊖_{AC} CONV. OUTLET (AIR CON)
- S₁ SINGLE SWITCH IN ONE GANG
- S₂ DOUBLE SWITCH IN ONE GANG
- S₃ TRIPLE SWITCH IN ONE GANG
- 2WS TWO-WAY SWITCH
- ① CIRCUIT HOMERUN
- LP-1 LIGHT & POWER OUTLET PANEL (GRD. FLR.)
- LP-2 LIGHT & POWER OUTLET PANEL (SEC. FLR.)
- MDP MAIN DISTRIBUTION PANEL
- ➡ SERVICE ENTRANCE

AGENCY	DRAWN BY:	END USER:	ENDORSED BY:	PROJECT TITLE:	REC. APPROVAL:	APPROVED BY:	SHEET NO.
CYSU	 A.L. LLAMADO	 G. DESENGAÑO	 D.R. ESCAÑO	REPAIR & IMPV'T. OF WHITE HOUSE	 E. A. POLINGA	 H. D. ROBLES	12
	PPS STAFF	DIR. OBA	DIR. PPS				13

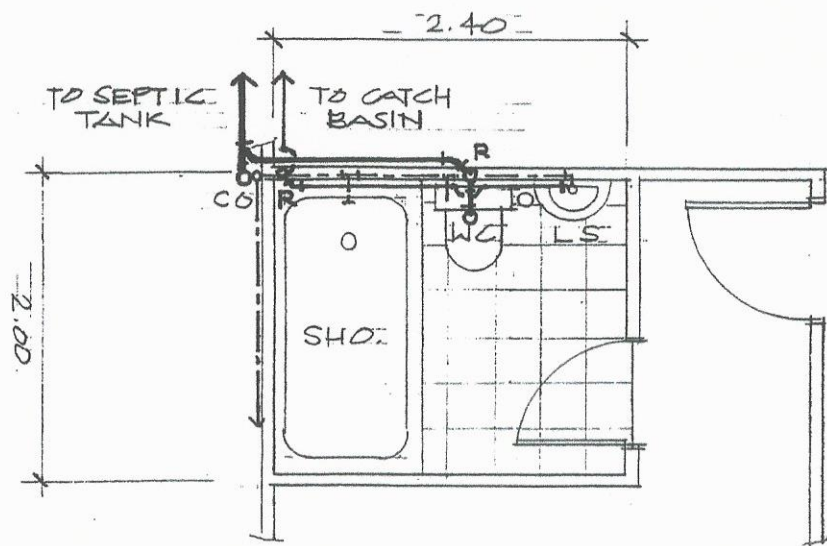


CR (MASTER BEDROOM)

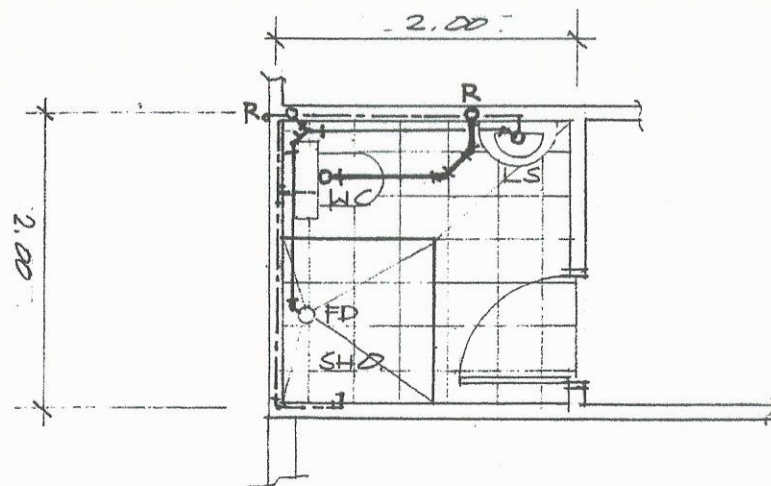

CR (SECOND FLOOR)

LEGEND:

- WATER LINE LAYOUT
- SEWER LINE TO CATCH BASIN
- SEWER LINE TO SEPTIC TANK
- WC WATER CLOSET
- LS LAVATORY SINK
- SHO. SHOWER
- FD FLOOR DRAIN
- CO CLEAN OUT
- R RISER

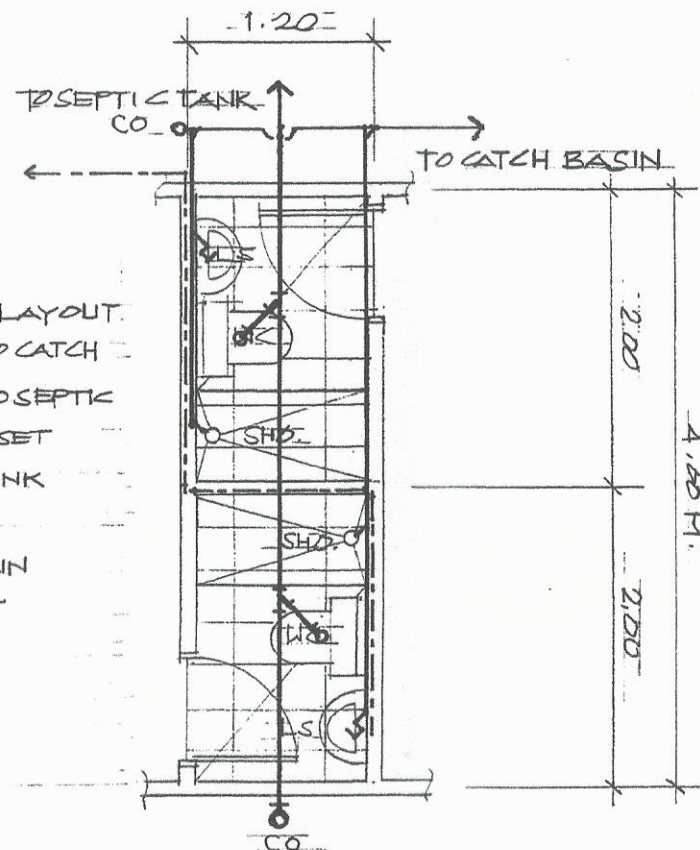

CR (LAUNDRY/BEDROOM-2)

PLUMBING LAYOUT

SCALE: 1:50 MTRS

AGENCY	DRAWN BY:	END USER:	ENDORSED BY:	PROJECT TITLE:	REC. APPROVAL:	APPROVED BY:	SHEET NO.
CVSU	 A.L. LAMADO PPS STAFF	 G. DE SENGANO DIR. OBA	 D.R. ESCANO DIR. PPS	REPAIR & IMPV'T. OF WHITE HOUSE	 E.A. POLINGA VPASS	 H.D. ROBLES PRESIDENT	B 13 13