



⊘
1

STAINLESS GRILL DOOR W/
W/ COMPLETE ACCESSORIES &
STAINLESS BARREL BOLT
6 SETS

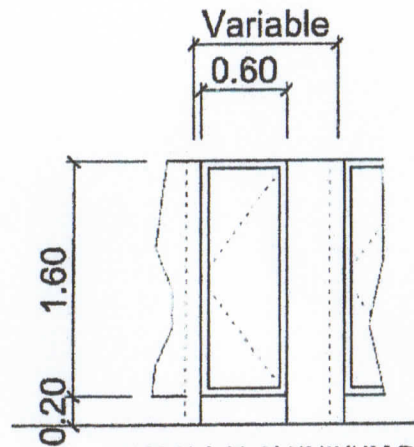

⊘
2

 0.60 X 1.60 ALUMINUM DOOR
(YP/ BUS BODY)
W/ COMPLETE ACCESSORIES &
DOOR LOCK W/ INDICATOR
18 SETS



SCHEDULE OF DOORS


SCALE

1 : 50 MTS.


PREPARED BY: S. B. BAYOT JR. PPU CEBT		ENDORSED BY: C. M. SIGNO DEAN, CVSU, CARMONA CAMPUS		REC. APPROVAL: O. E. DELLOS REYES DIRECTOR PPU		APPROVED BY: H. D. ROBLES PPU CVSU		PROJECT TITLE & LOCATION: REHABILITATION OF COMFORT ROOMS CVSU CARMONA CAMPUS ANDRY CARMONA, CAVITE	IMPLEMENTING AGENCY: CAVITE STATE UNIVERSITY	EXIT NO. 4
CHECKED BY: E. N. RODEROS JR. PPU CEBT		ENDORSED BY: C. M. SIGNO DEAN, CVSU, CARMONA CAMPUS		REC. APPROVAL: O. E. DELLOS REYES DIRECTOR PPU		APPROVED BY: H. D. ROBLES PPU CVSU		PROJECT TITLE & LOCATION: REHABILITATION OF COMFORT ROOMS CVSU CARMONA CAMPUS ANDRY CARMONA, CAVITE	IMPLEMENTING AGENCY: CAVITE STATE UNIVERSITY	EXIT NO. 4

Bid Bulletin No. 2

Rehabilitation of Comfort Rooms at CvSU Carmona Campus

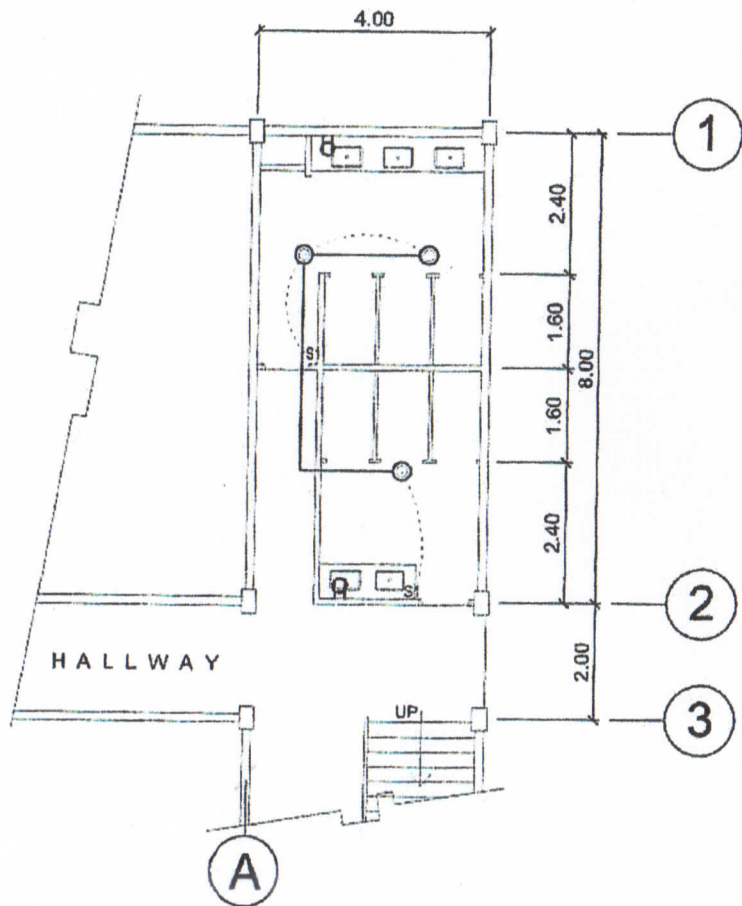


ELECTRICAL LAYOUT
REV. GRD. FLR. GIRLS CR (NORTH WING)
 SCALE 1 : 125 MTS.

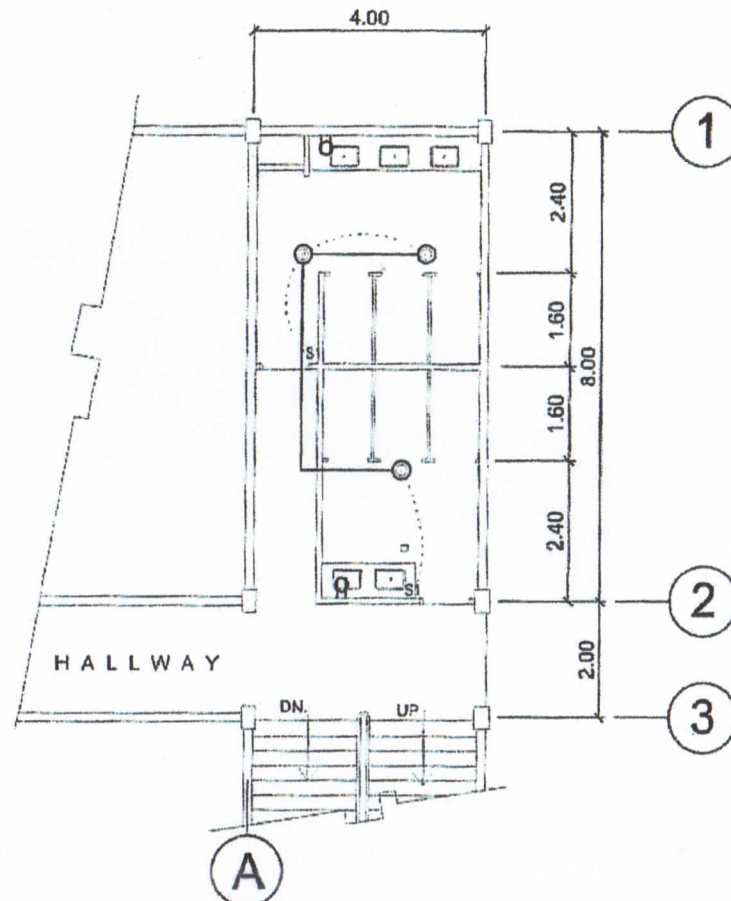

ELECTRICAL LAYOUT
REV. 2ND. FLR. CR (NORTH WING)
 SCALE 1 : 125 MTS.


PREPARED BY: R. P. PERA EPU	DESIGNED BY: C. M. SIGNO DCAN - CIVIL CARMONA CAMPUS	APPROVED BY: O. B. PELOS REYES DIRECTOR - EPU	REC. APPROVAL: C. A. FOUNGA VPAS - CIVIL	APPROVED BY: H. D. ROBLES RES - CUSU	PROJECT TITLE / LOCATION: REHABILITATION OF COMFORT ROOMS CIVIL CARMONA CAMPUS - MAQUITA CARMONA, CAMPE	IMPLEMENTING AGENCY: CAVITE STATE UNIVERSITY	DWG. NO. E - 1
-----------------------------------	--	---	--	--	---	---	-------------------

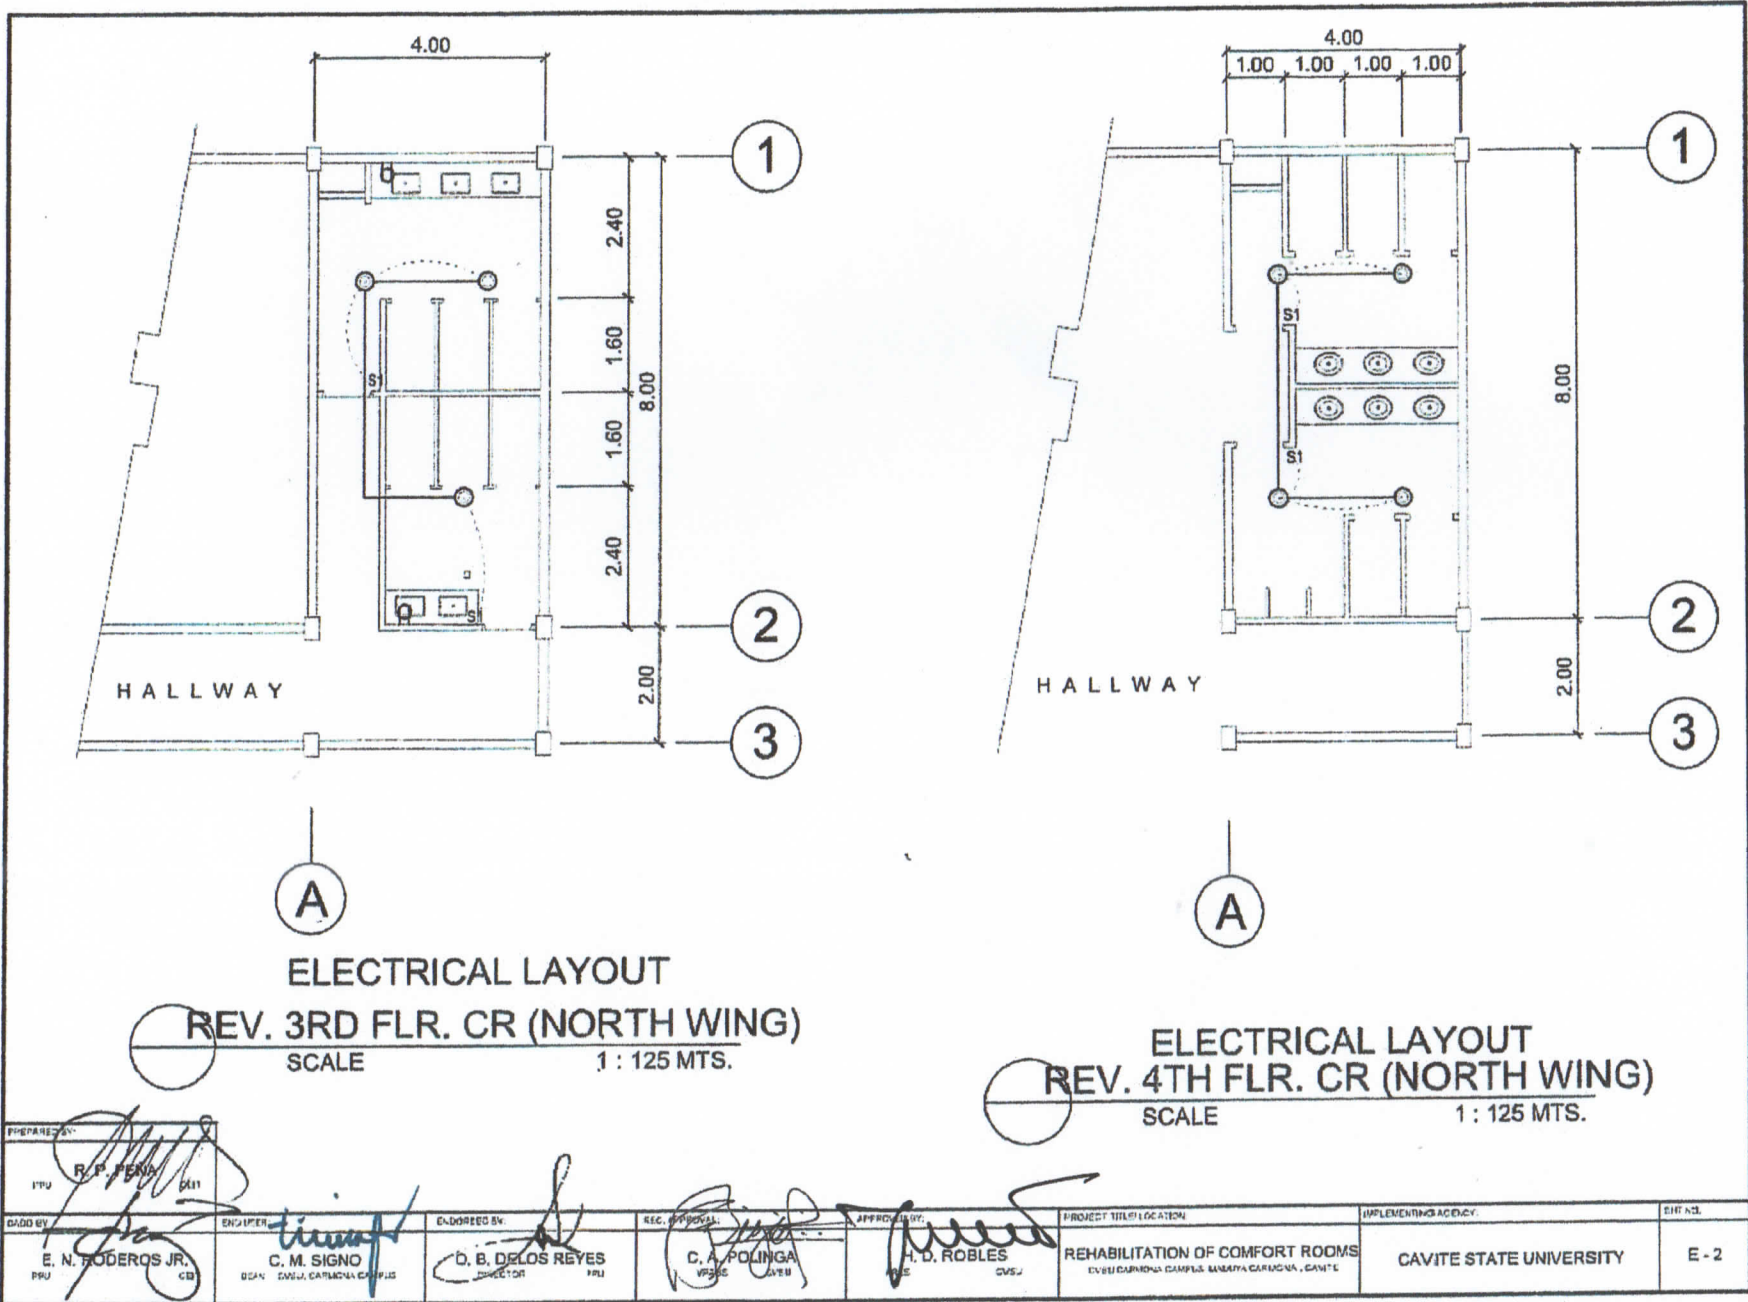

ELECTRICAL LAYOUT
REV. 3RD FLR. CR (NORTH WING)
 SCALE 1 : 125 MTS.

ELECTRICAL LAYOUT
REV. 4TH FLR. CR (NORTH WING)
 SCALE 1 : 125 MTS.

PREPARED BY: R. P. FERRA IPU	ENGINEER: C. M. SIGNO DCAN - CARMONA CAMPUS	ENDORSED BY: D. B. DELOS REYES DIRECTOR	REC. APPROVAL: C. A. POLINGA VP/EE	APPROVED BY: H. D. ROBLES CNSJ	PROJECT TITLE/LOCATION: REHABILITATION OF COMFORT ROOMS ENUE CARMONA CAMPUS, SANATA CARMONA, CAVITE	IMPLEMENTING AGENCY: CAVITE STATE UNIVERSITY	SHEET NO. E - 2
------------------------------------	---	---	--	--------------------------------------	---	---	--------------------

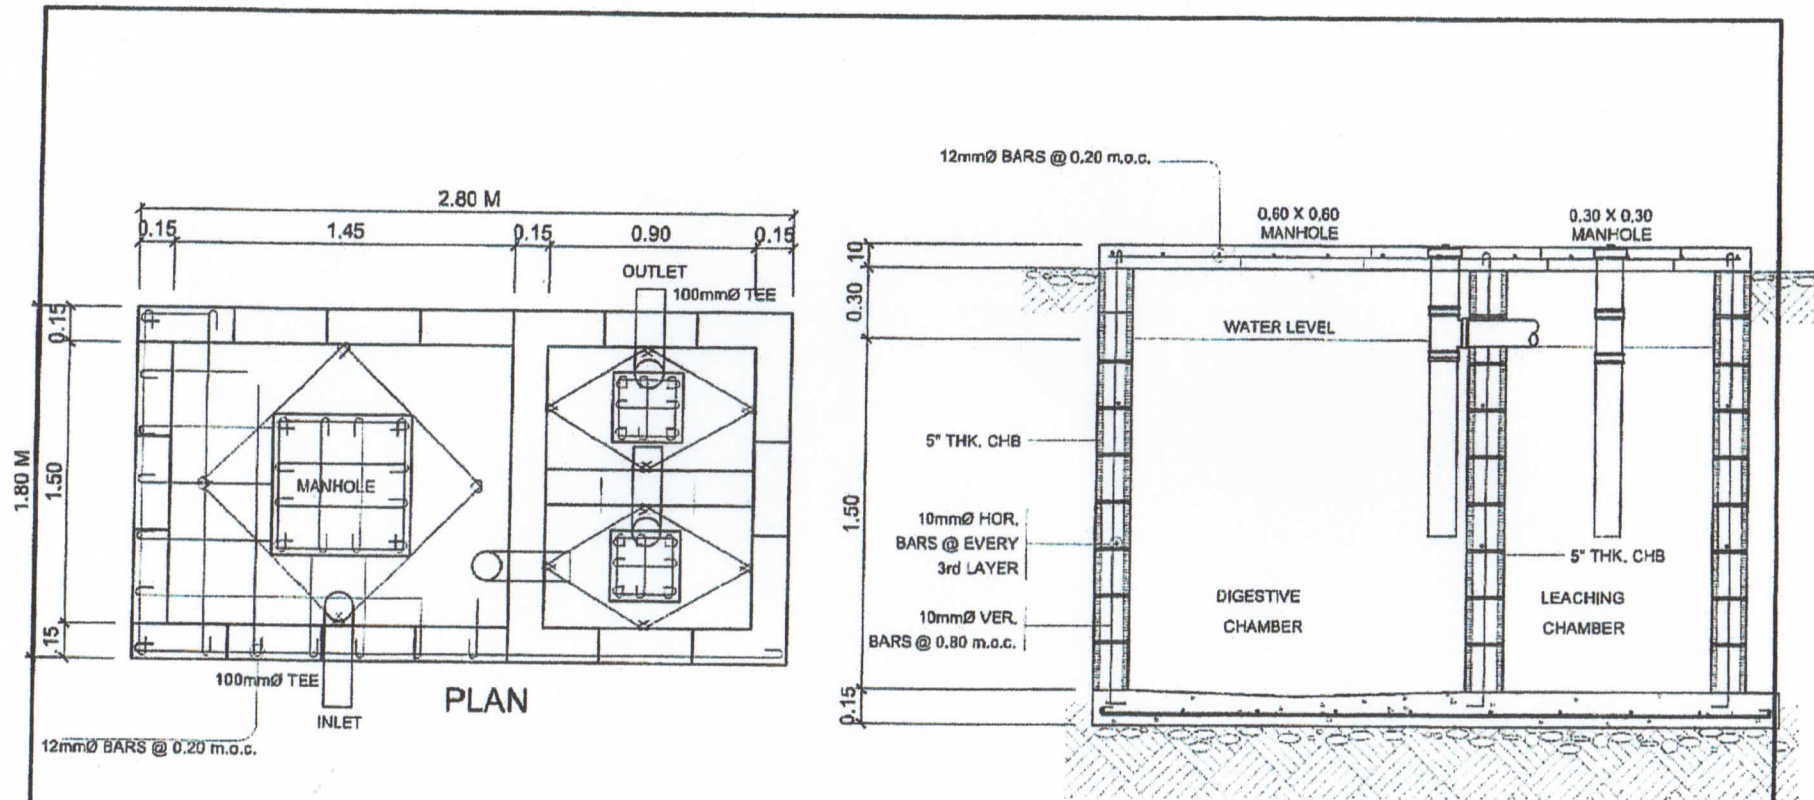

DETAIL OF SEPTIC TANK
 SCALE 1 : 20 MTS.

PREPARED BY: S. B. BAYOT JR. <small>YPU</small>	ENCL. SER. <i>triof</i> C. M. SIGNO <small>DSAV CVSU, CARMONA CAMPUS</small>	ENDORSED BY: <i>[Signature]</i> O. B. DELLOS REYES <small>PPU DIRECTOR</small>	REVIEWED BY: <i>[Signature]</i> C. X. POLINCA <small>PPU ASST. DIR.</small>	APPROVED BY: <i>[Signature]</i> H. D. ROBLES <small>PPU DIR.</small>	PROJECT TITLE / LOCATION: REHABILITATION OF COMFORT ROOMS <small>CVSU CARMONA CAMPUS, LASUNTA CARMONA, CAVITE</small>	IMPLEMENTING AGENCY: CAVITE STATE UNIVERSITY	SHEET NO.: P - 6
--	--	--	---	--	--	--	----------------------------