




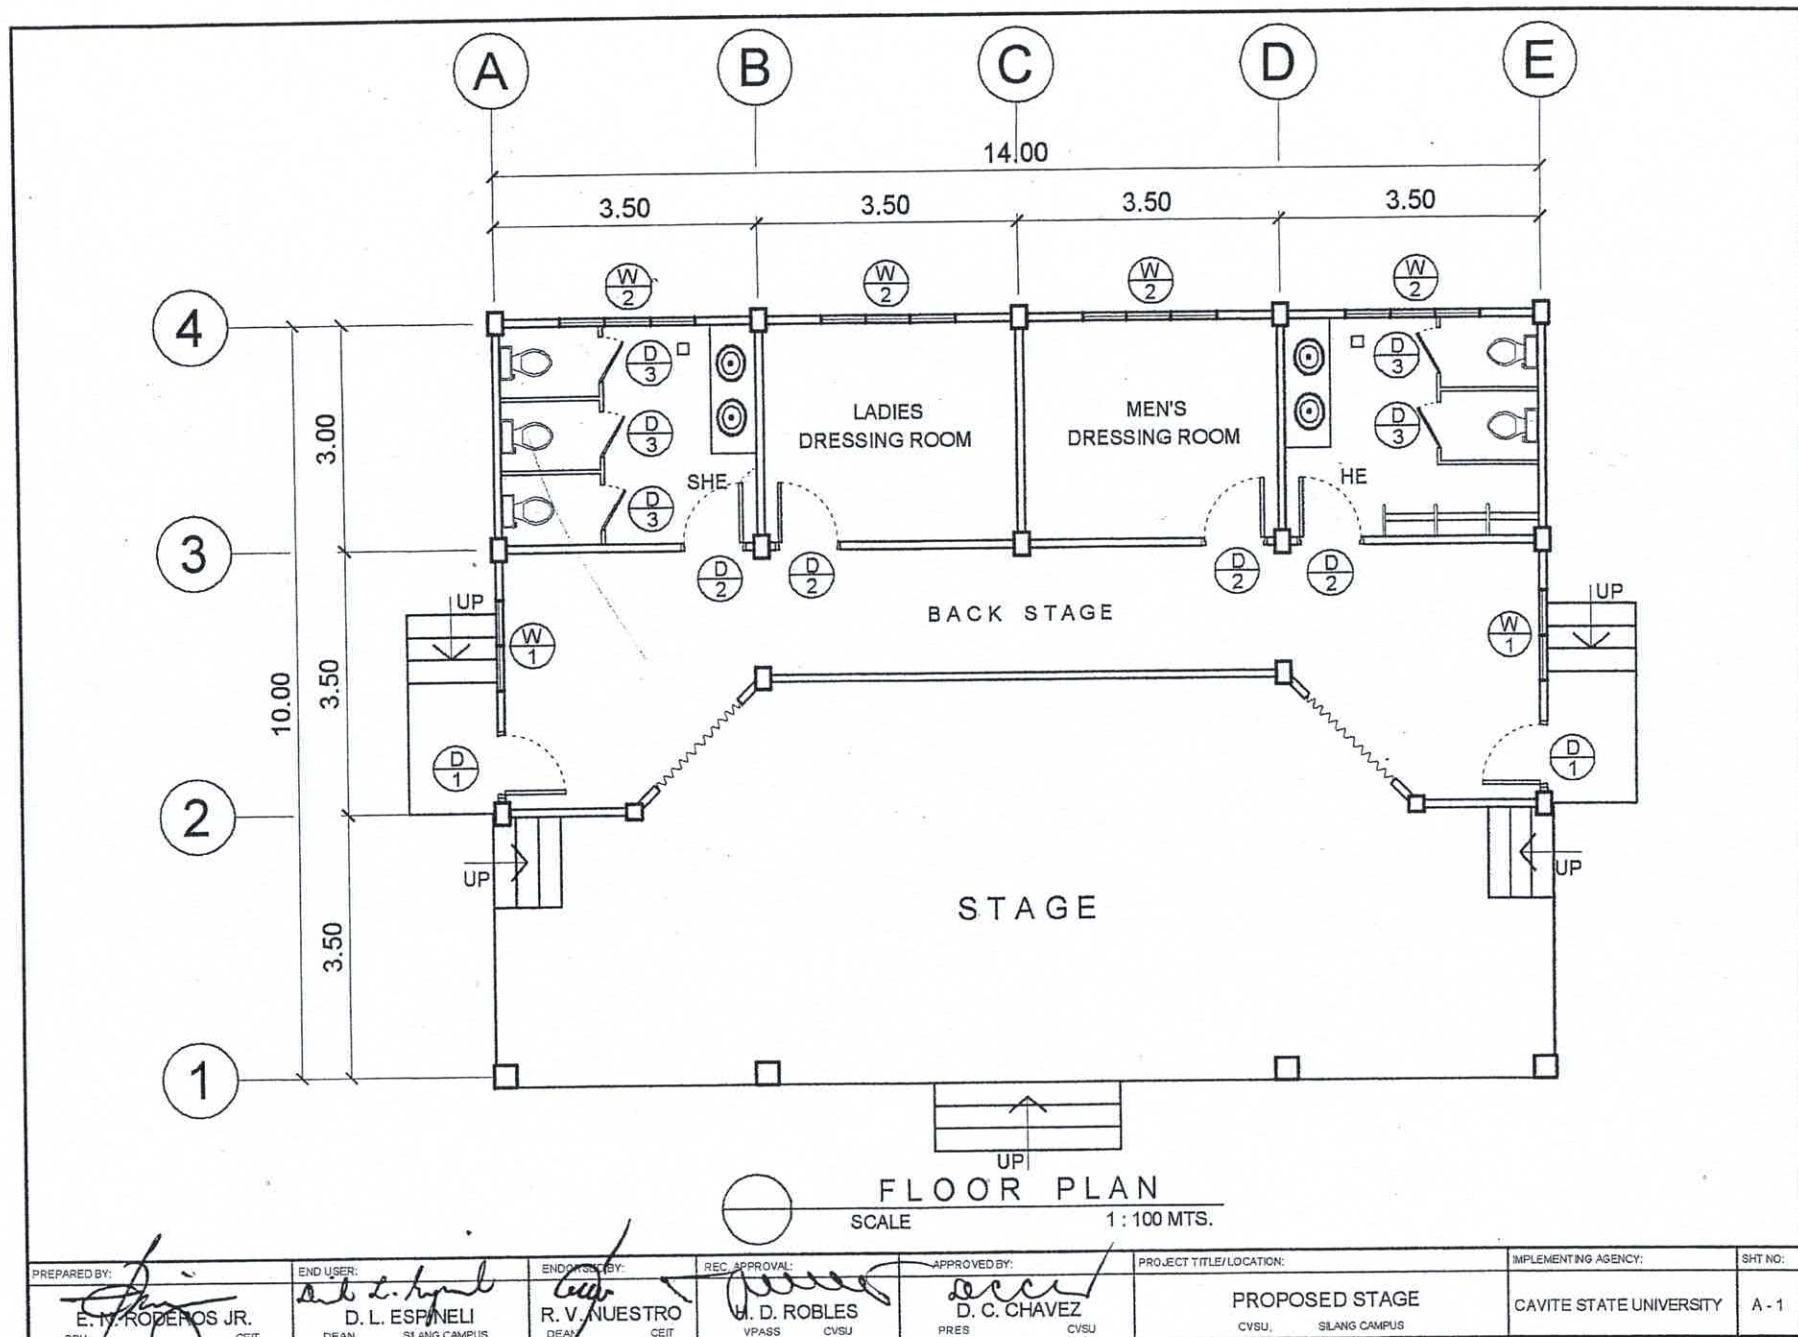

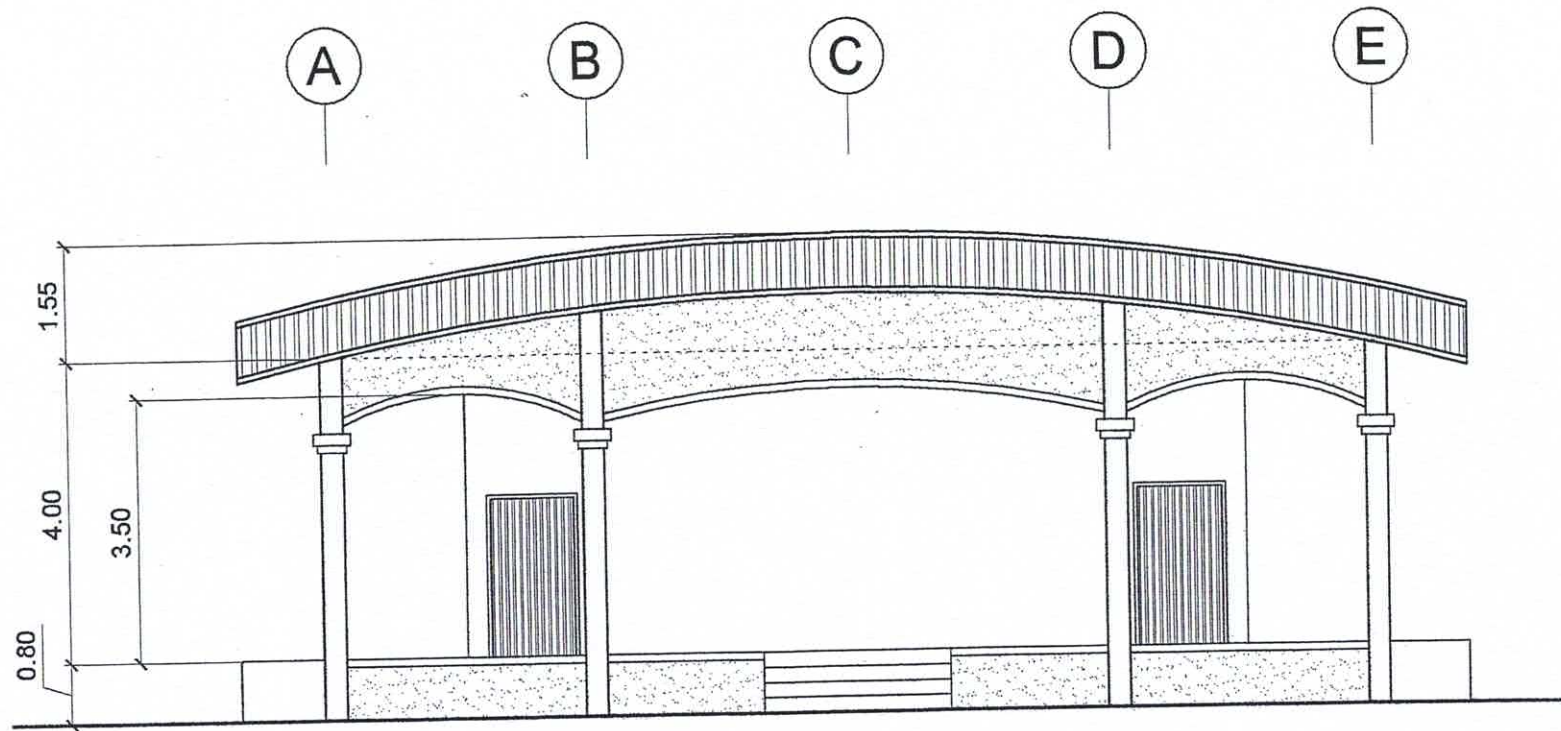


FRONT ELEVATION
SCALE 1 : 100 MTS.

PREPARED BY: <i>E. N. Roderos Jr.</i> E. N. RODEROS JR. PPU	END USER: <i>D. L. Espineli</i> D. L. ESPINELI DEAN SLANG CAMPUS	ENDORSED BY: <i>R. V. Nuestro</i> R. V. NUESTRO DEAN CEIT	REC. APPROVAL: <i>M. D. Robles</i> M. D. ROBLES VPASS CVSU	APPROVED BY: <i>D. C. Chavez</i> D. C. CHAVEZ PRES CVSU	PROJECT TITLE/LOCATION: PROPOSED STAGE CVSU, SLANG CAMPUS	IMPLEMENTING AGENCY: CAVITE STATE UNIVERSITY	SHT NO.: A - 2
--	--	---	--	---	---	---	-------------------

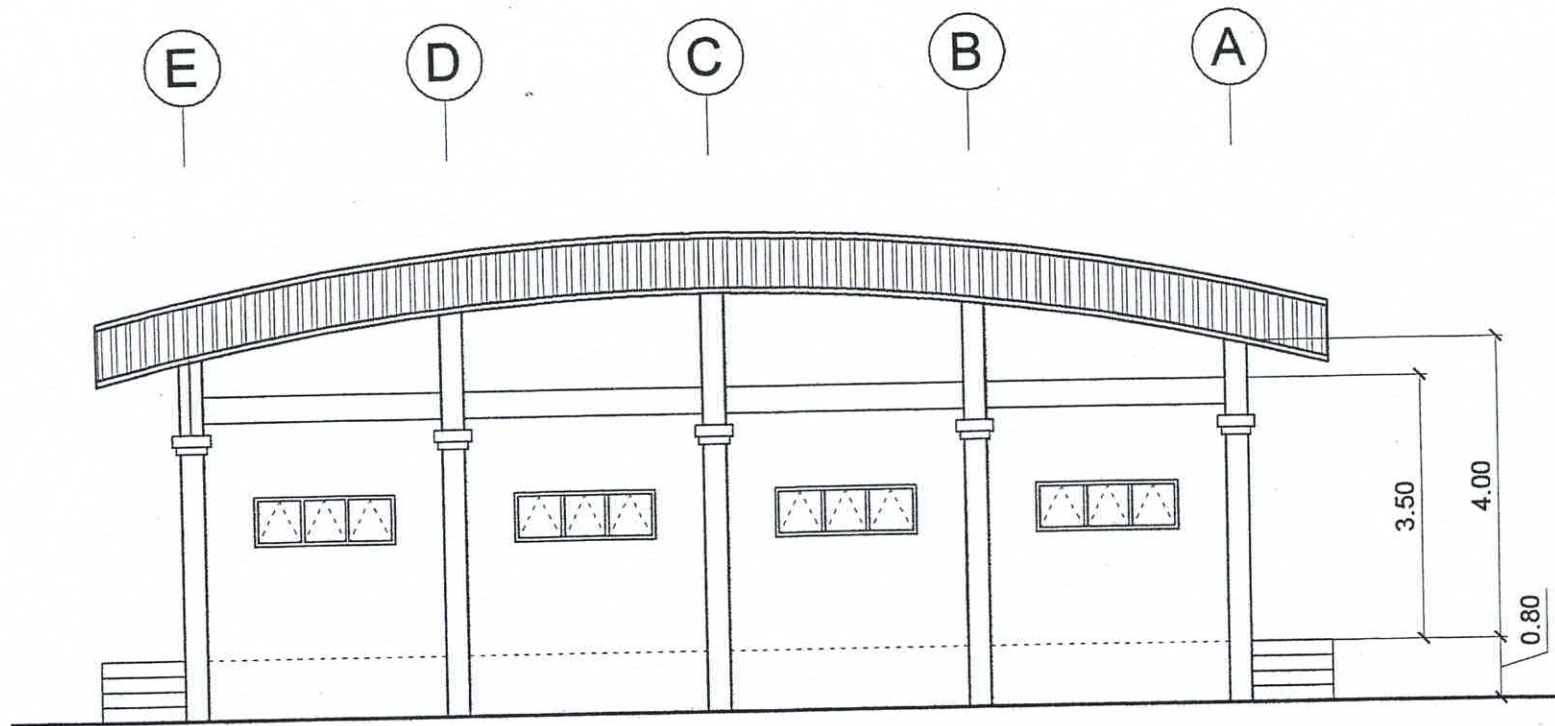

REAR ELEVATION
SCALE 1 : 100 MTS.

PREPARED BY: <i>E. N. Roderos Jr.</i> E. N. RODEROS JR. PPU	END USER: <i>D. L. Esneli</i> D. L. ESNELI DEAN SILANG CAMPUS	ENDORSED BY: <i>R. V. Nuestro</i> R. V. NUESTRO DEAN CEIT	REC. APPROVAL: <i>H. D. Robles</i> H. D. ROBLES VPASS CVSU	APPROVED BY: <i>D. C. Chavez</i> D. C. CHAVEZ PRES CVSU	PROJECT TITLE/LOCATION: PROPOSED STAGE CVSU, SILANG CAMPUS	IMPLEMENTING AGENCY: CAVITE STATE UNIVERSITY	SHT NO: A - 3
--	---	---	--	---	--	---	------------------

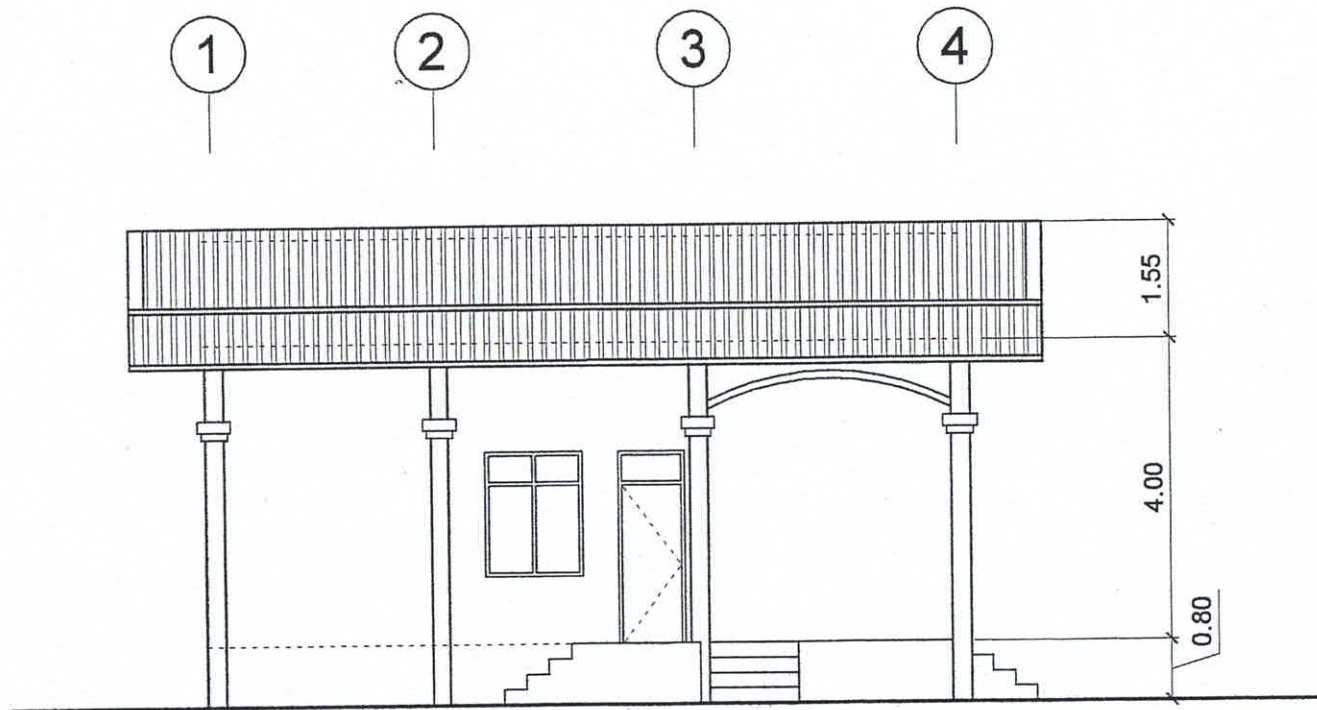


LEFT SIDE ELEVATION

SCALE


1 : 100 MTS.

PREPARED BY: <i>E. N. RODEROS JR.</i> PPU	END USER: <i>D. L. ESPINELI</i> DEAN SILANG CAMPUS	ENDORSED BY: <i>R. V. NUESTRO</i> DEAN CEIT	REC. APPROVAL: <i>H. D. ROBLES</i> VPASS CVSU	APPROVED BY: <i>D. C. CHAVEZ</i> PRES CVSU	PROJECT TITLE/LOCATION: PROPOSED STAGE CVSU, SILANG CAMPUS	IMPLEMENTING AGENCY: CAVITE STATE UNIVERSITY	SHT NO: A - 4
---	---	--	--	---	--	---	------------------

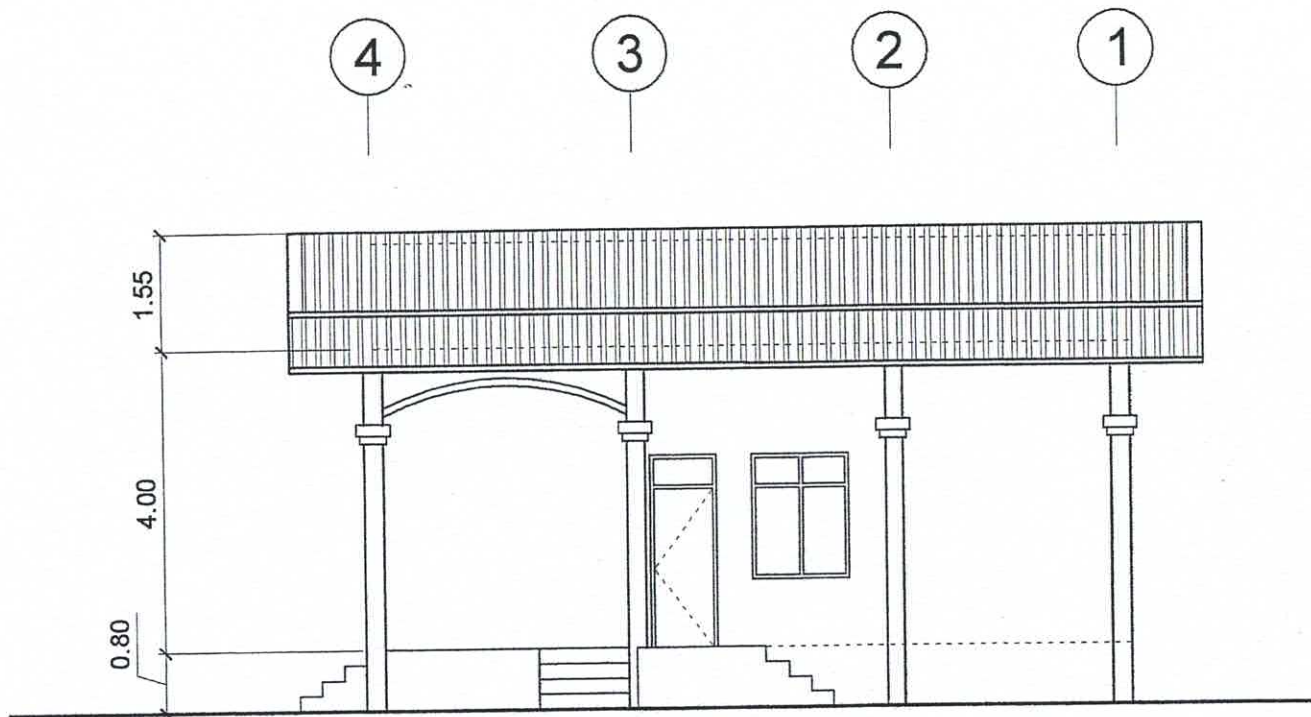


RIGHT SIDE ELEVATION
SCALE 1:100 MTS.

PREPARED BY: <i>E. N. Roderos Jr.</i> E. N. RODEROS JR. PPU CEIT	END USER: <i>D. L. Espineli</i> D. L. ESPINELI DEAN SILANG CAMPUS	ENDORSED BY: <i>R. V. Nuestro</i> R. V. NUESTRO DEAN CEIT	REC. APPROVAL: <i>H. D. Robles</i> H. D. ROBLES VPASS CVSU	APPROVED BY: <i>D. C. Chavez</i> D. C. CHAVEZ PRES CVSU	PROJECT TITLE/LOCATION: PROPOSED STAGE CVSU, SILANG CAMPUS	IMPLEMENTING AGENCY: CAVITE STATE UNIVERSITY	SHT NO.: A - 5
---	--	--	---	--	--	---	-------------------

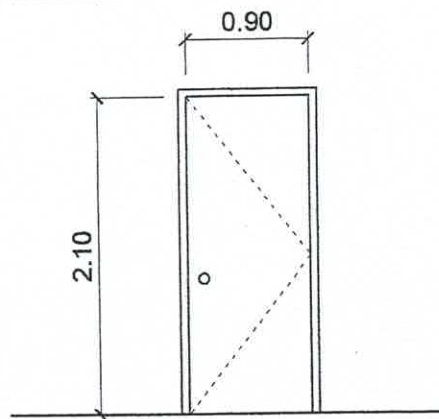


(D)
1

0.90 X 2.10 FLUSH DOOR
W/ COMPLETE ACCESSORIES
2 SETS

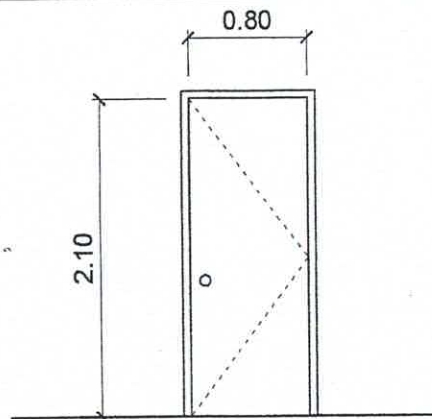


(D)
2

0.80 X 2.10 FLUSH DOOR
W/ COMPLETE ACCESSORIES
4 SETS

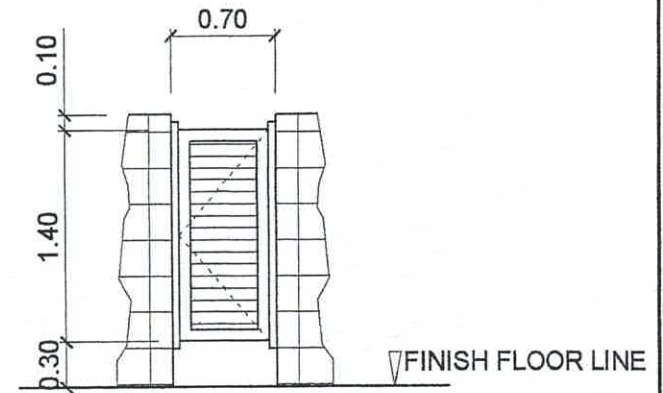


(D)
3

0.60 X 1.40 PVC DOOR
W/ COMPLETE ACCESSORIES
5 SETS

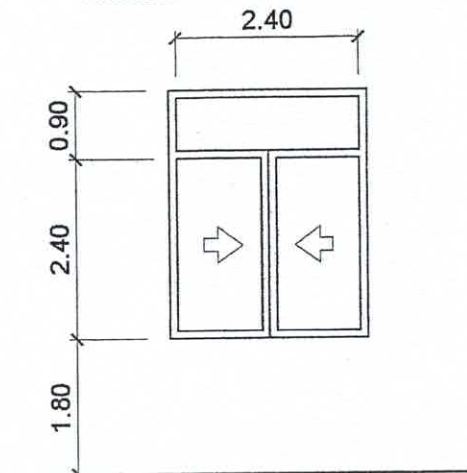

(W)
1


ALUMINUM SLIDING WINDOW COMPLETE W/
ALL ACCESSORIES W/ $\frac{3}{8}$ " THK COLORED GLASS
ON COLORED POWDER COATED FINISH
ALUMINUM FRAMING
2 SETS

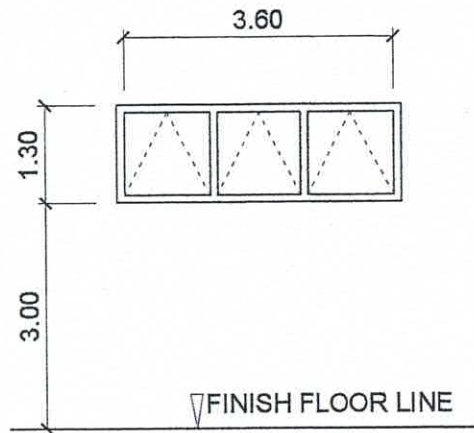

(W)
2

ALUMINUM AWNING WINDOW COMPLETE W/
ALL ACCESSORIES W/ $\frac{3}{8}$ " THK COLORED GLASS
ON COLORED POWDER COATED FINISH
ALUMINUM FRAMING
4 SETS


PREPARED BY: <i>E. N. RODEROS JR.</i> PPU	END USER: <i>D. L. ESPINELI</i> DEAN SLANG CAMPUS	ENDORSED BY: <i>R. V. NUESTRO</i> DEAN CEIT	REC. APPROVAL: <i>H. D. ROBLES</i> VPASS CVSU	APPROVED BY: <i>D. C. CHAVEZ</i> PRES CVSU	PROJECT TITLE/LOCATION: PROPOSED STAGE CVSU, SLANG CAMPUS	IMPLEMENTING AGENCY: CAVITE STATE UNIVERSITY	SHT NO: A - 8
---	--	--	--	---	---	---	------------------

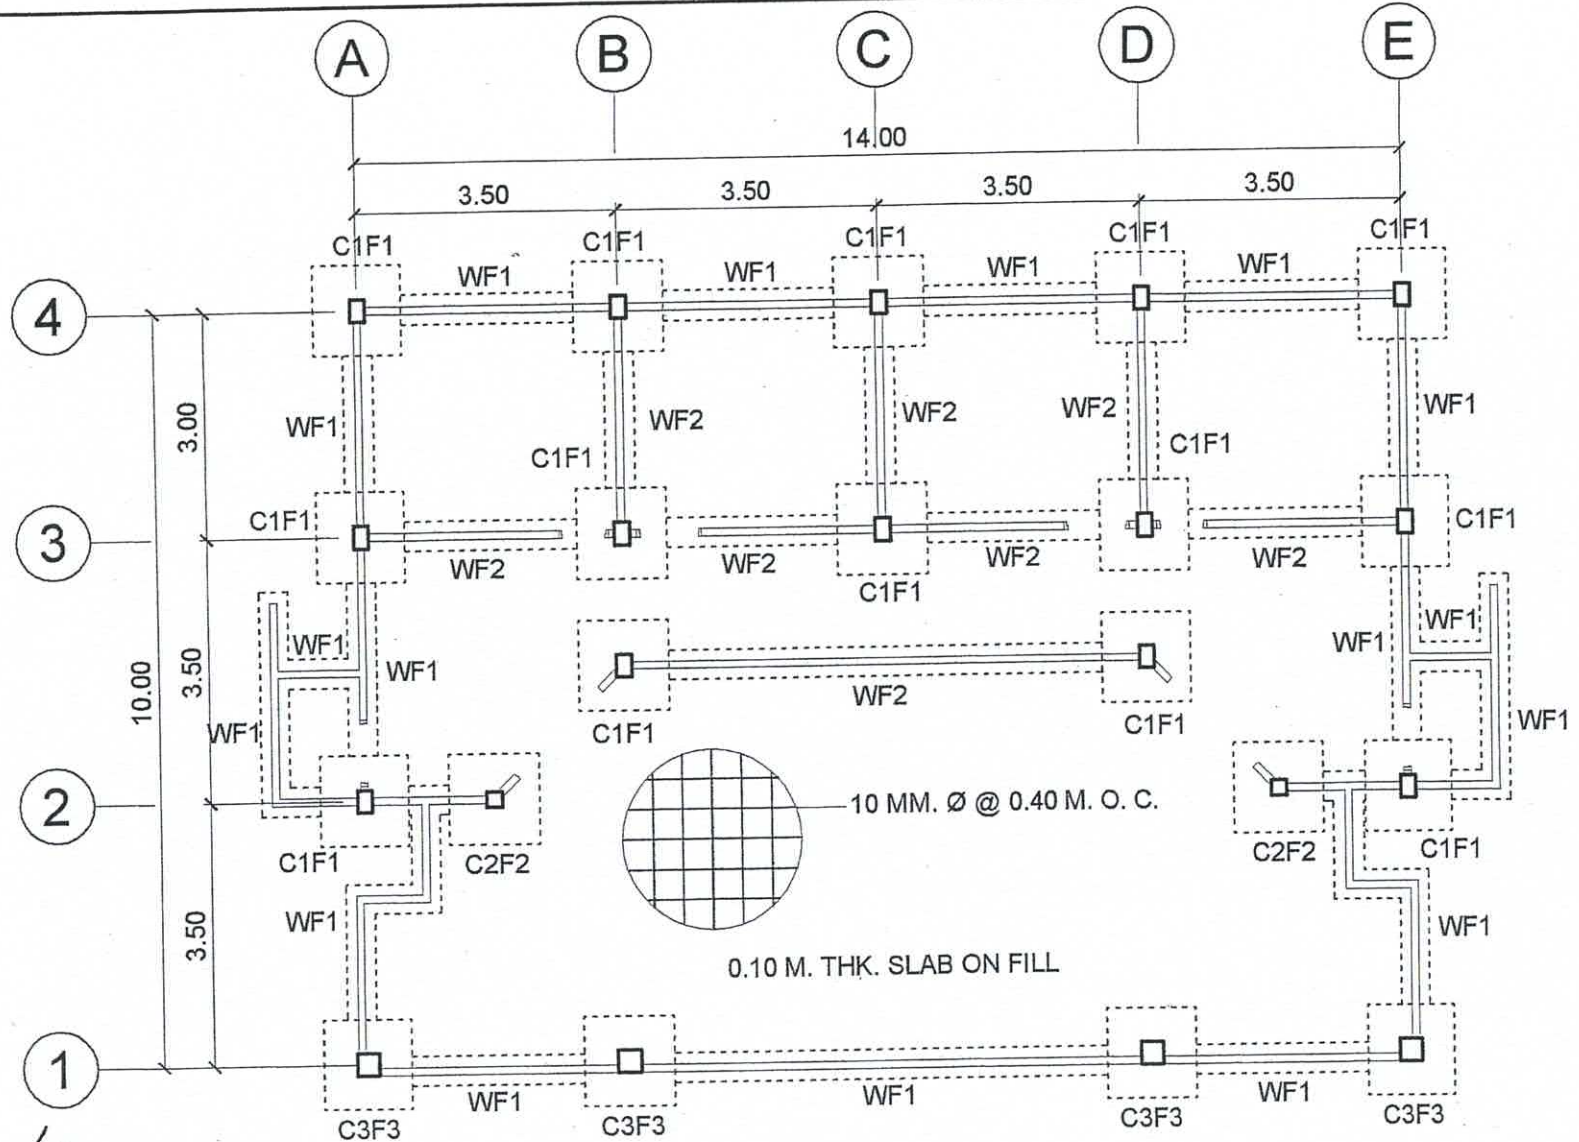


PREPARED BY: <i>E. N. RODEROS JR.</i> PPU CEIT		END USER: <i>D. L. ESPINELI</i> DEAN SILING CAMPUS		ENDORSE BY: <i>R. V. NUESTRO</i> DEAN CEIT		RES. APPROVAL: <i>H. D. ROBLES</i> VPASS CVSU		APPROVED BY: <i>D. C. CHAVEZ</i> PRES CVSU		PROJECT TITLE/LOCATION: PROPOSED STAGE CVSU, SILING CAMPUS		IMPLEMENTING AGENCY: CAVITE STATE UNIVERSITY		SHT NO: S - 1	
--	--	--	--	--	--	---	--	--	--	--	--	---	--	------------------	--

FOUNDATION PLAN

SCALE 1 : 100 MTS.

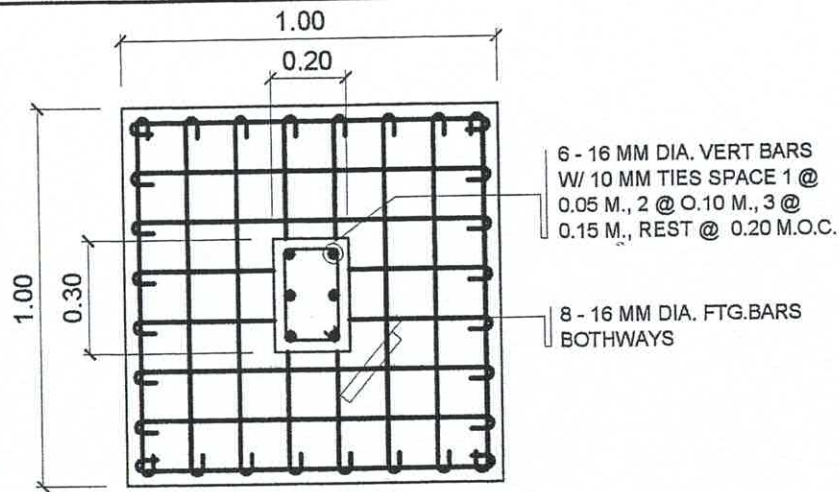


P L A N

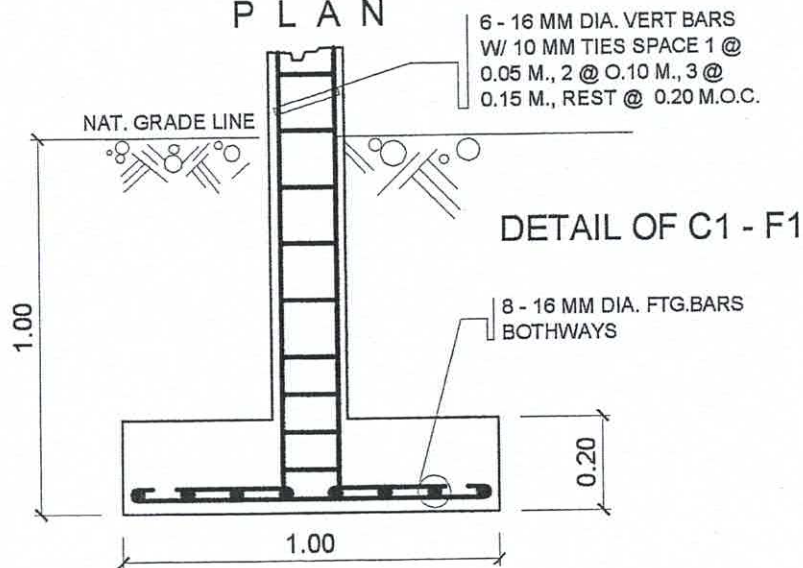


DETAIL OF C1 - F1

SECTION

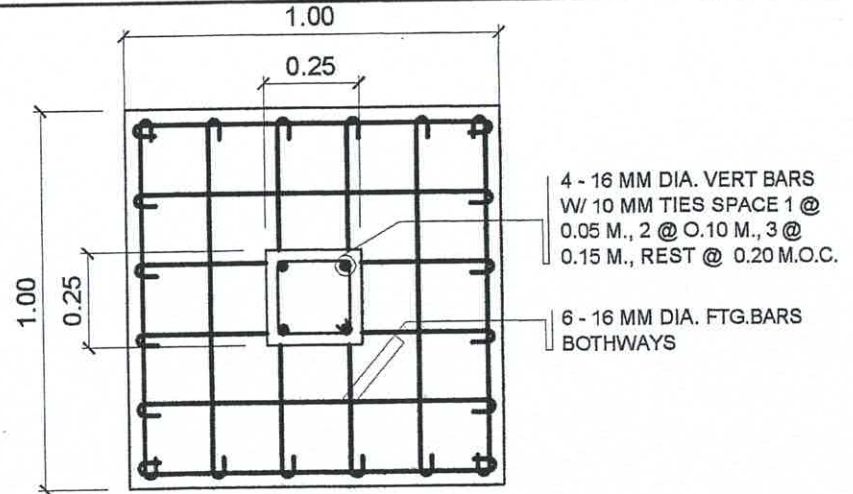

P L A N


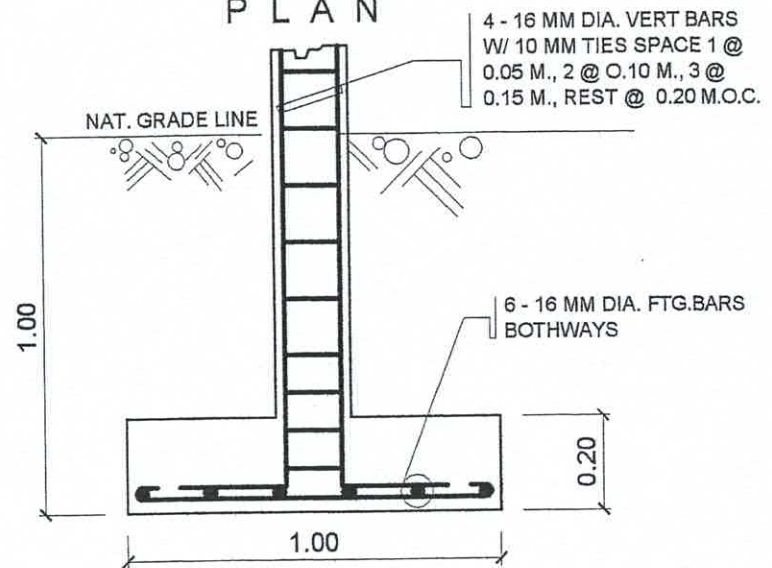


SECTION
DETAIL OF C2 - F2

SCALE



1 : 20M

PREPARED BY: E. N. RODEROS JR. PPU	END USER: D. L. ESINELI DEAN SLANG CAMPUS	ENDORSED BY: R. V. NUESTRO DEAN CEIT	REC. APPROVAL: H. D. ROBLES VPASS CVSU	APPROVED BY: D. C. CHAVEZ PRES CVSU	PROJECT TITLE/LOCATION: CVSU, SLANG CAMPUS	IMPLEMENTING AGENCY: CAVITE STATE UNIVERSITY	SHT NO: S - 2
--	--	---	---	--	---	---	------------------

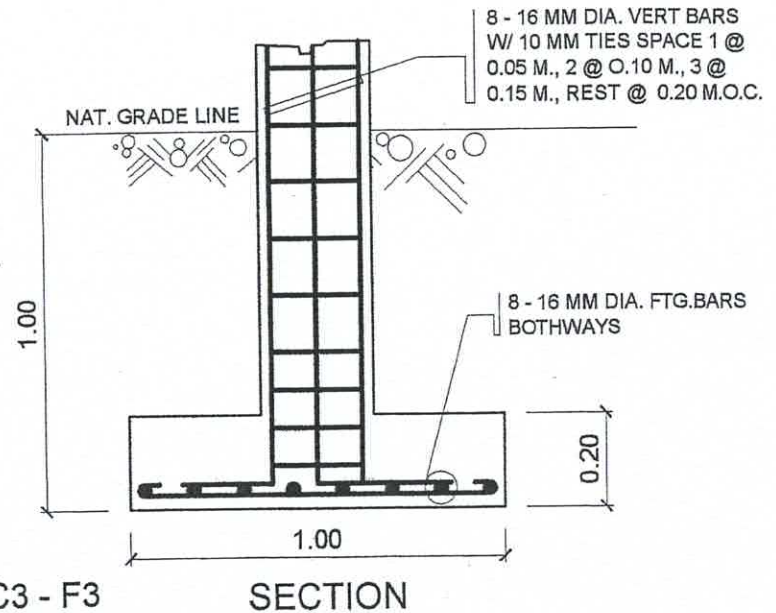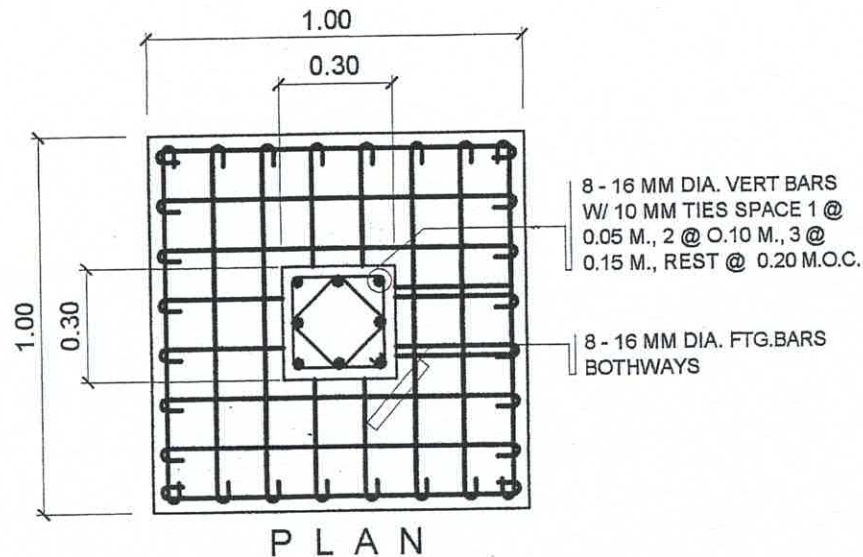


DETAIL OF C3 - F3

SCALE 1 : 20M

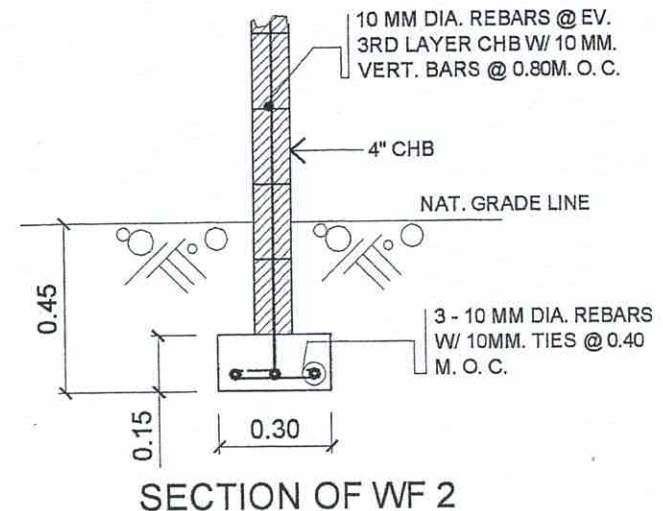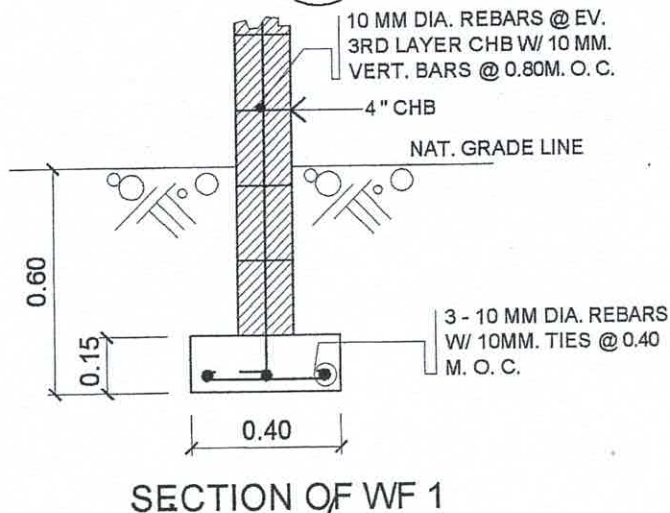


PREPARED BY: E. N. RODEROS JR. PPU CEIT	END USER: D. L. ESPINELI DEAN SLANG CAMPUS	ENDORSED BY: R. V. NUESTRO DEAN CEIT	REC. APPROVAL: H. D. ROBLES VPASS CVSU	APPROVED BY: D. C. CHAVEZ PRES CVSU	PROJECT TITLE/LOCATION: PROPOSED STAGE CVSU, SLANG CAMPUS	IMPLEMENTING AGENCY: CAVITE STATE UNIVERSITY	SHT NO: S - 3
--	---	---	---	--	---	---	------------------

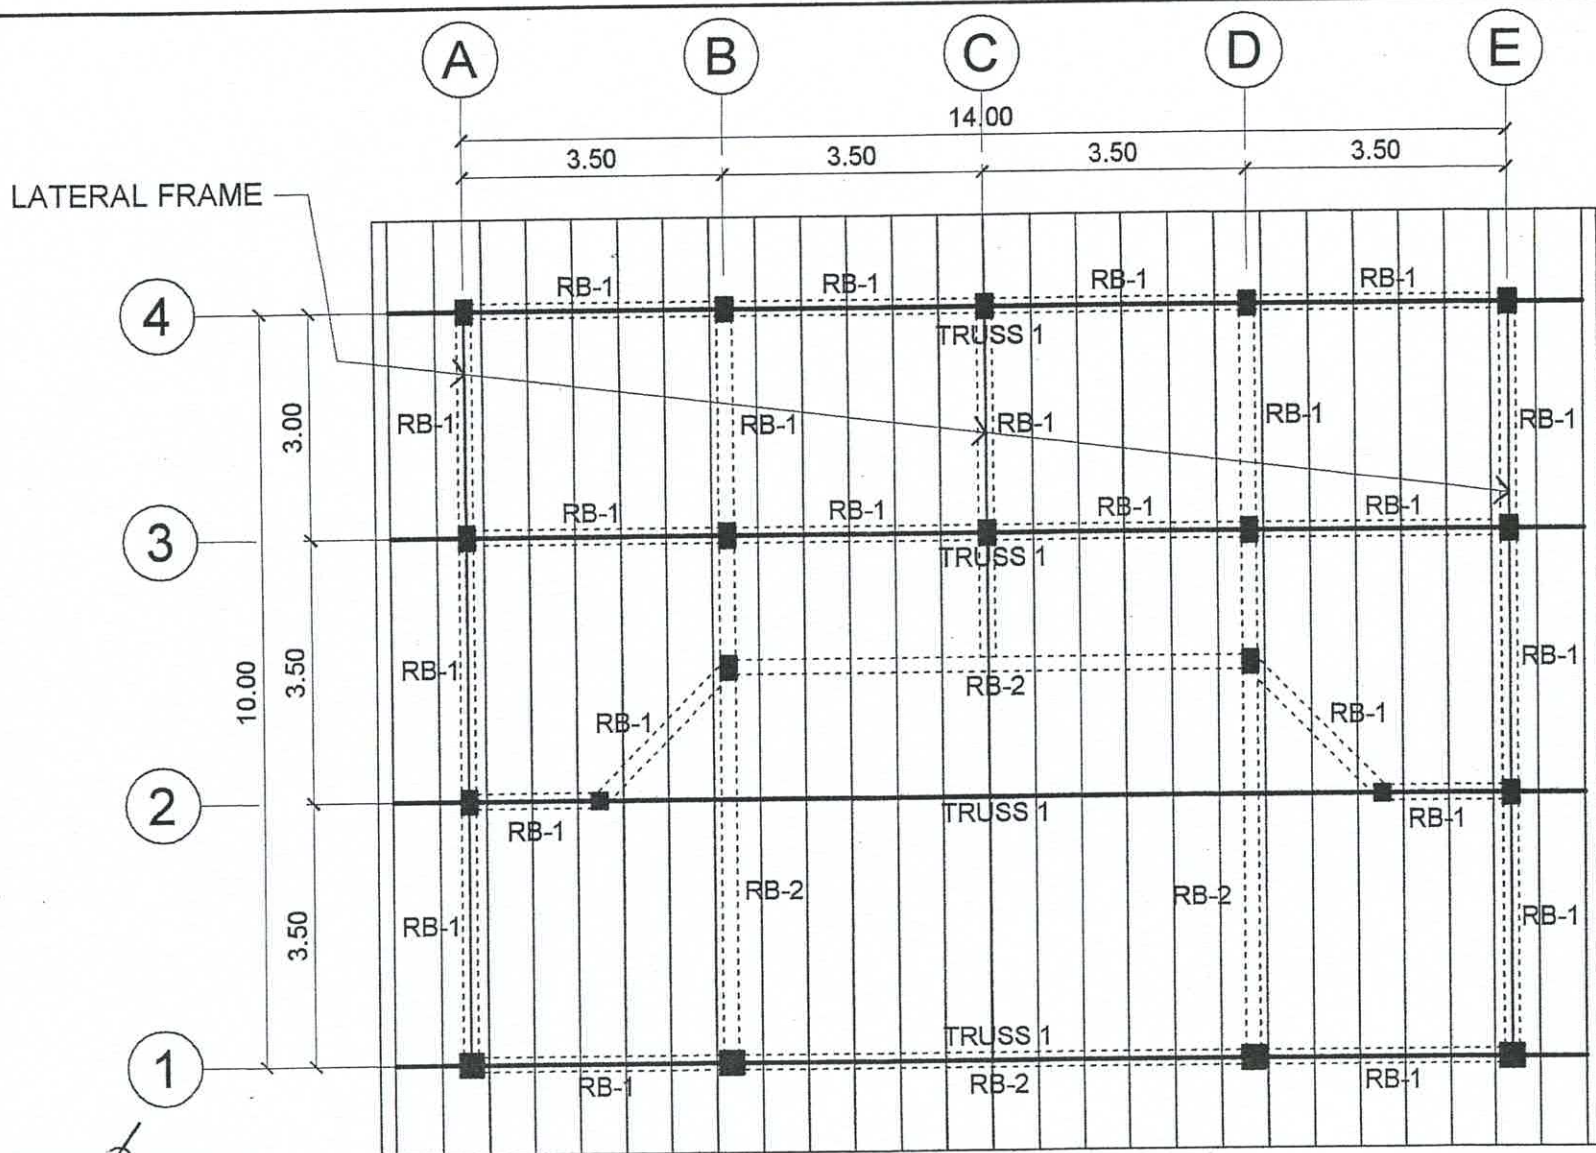

PREPARED BY: <i>[Signature]</i> E. N. RODEROS JR. PPU CEIT		END USER: <i>[Signature]</i> D. L. ESPINELI DEAN SLAG CAMPUS		ENDORSED BY: <i>[Signature]</i> R. V. NUESTRO DEAN CEIT		SEC. APPROVAL: <i>[Signature]</i> H. D. ROBLES VPASS CVSU		APPROVED BY: <i>[Signature]</i> D. C. CHAVEZ PRES CVSU		PROJECT TITLE/LOCATION: PROPOSED STAGE CVSU, SLAG CAMPUS		IMPLEMENTING AGENCY: CAVITE STATE UNIVERSITY		SHT NO.: S - 4	
---	--	---	--	--	--	--	--	---	--	--	--	---	--	-------------------	--


ROOF FRAMING PLAN

SCALE 1 : 100 MTS.

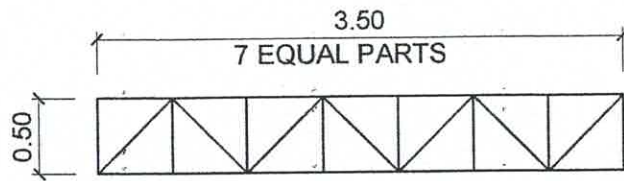


NOTES:
USE $1\frac{1}{2}$ " $\varnothing$ G. I. PIPE SCH. 40
FOR ALL MEMBERS

LATERAL FRAME

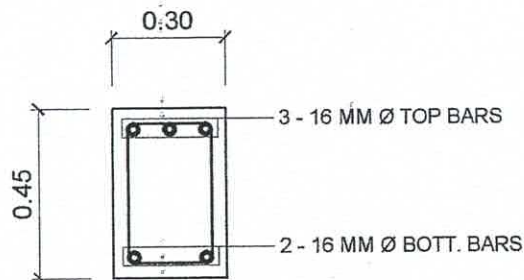


@ NEAR SUPPORT

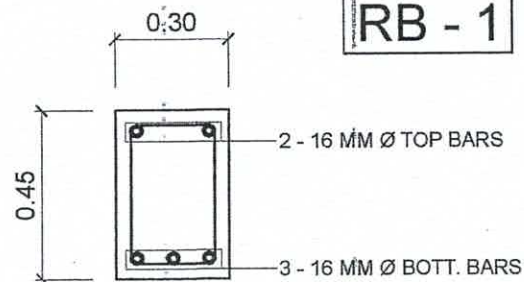


@ MID - SPAN

RB - 1

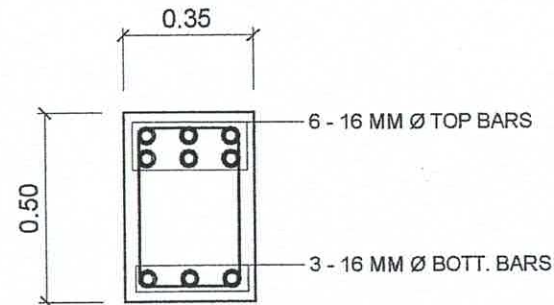

@ NEAR SUPPORT

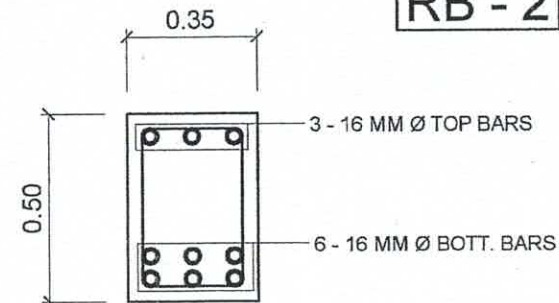

@ MID - SPAN

RB - 2

PREPARED BY:	
E. N. RODEROS JR.	
PPU	CEIT
STRUCTL. ENG.	
M. D. CASAS JR.	
DCE	CEIT

END USER:	
D. L. ESPINELI	
DEAN	SILANG CAMPUS

ENDORSED BY:	
R. V. NUESTRO	
DEAN	CEIT

REC. APPROVAL:	
H. D. ROBLES	
VPASS	CVSU

APPROVED BY:	
D. C. CHAVEZ	
PRES	CVSU

PROJECT TITLE/LOCATION:	
PROPOSED STAGE	
CVSU, SILANG CAMPUS	


IMPLEMENTING AGENCY:	
CAVITE STATE UNIVERSITY	

SHT NO:	
S - 6	


DET. SECTION OF ROOF BEAM

SCALE


1 : 20M

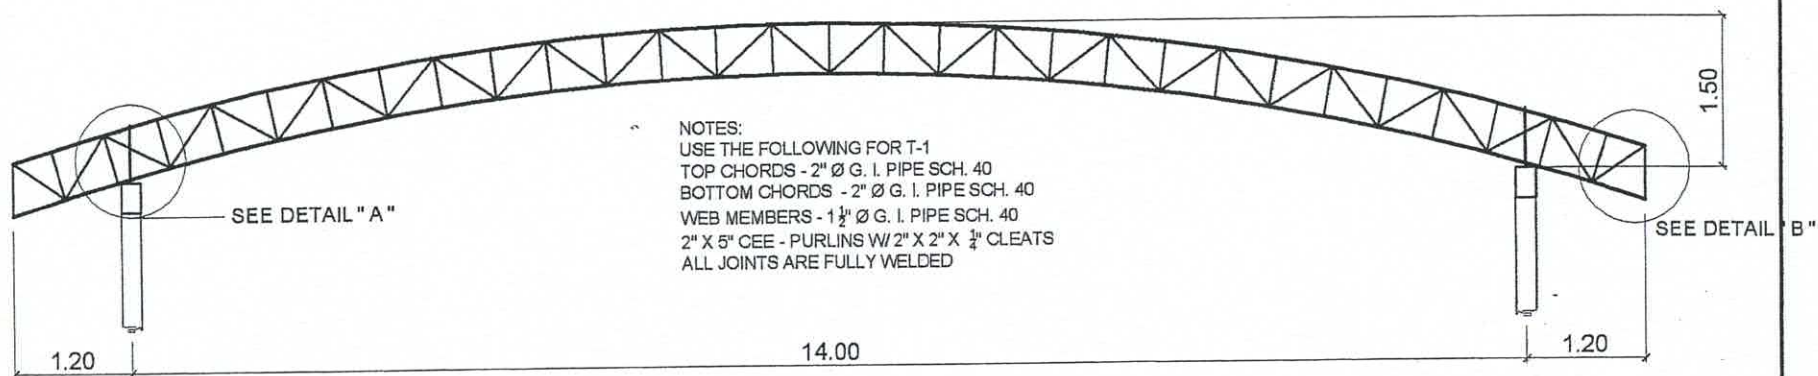


TRUSS DIAGRAM (TRUSS 1)
 SCALE 1 : 50M

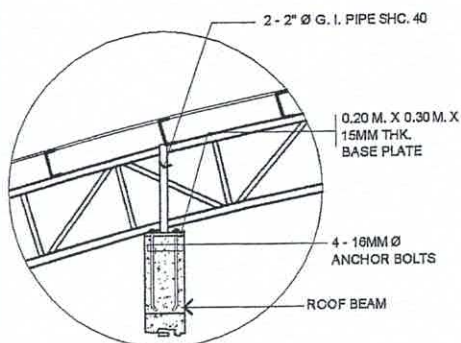

DETAIL "A"
 SCALE 1: 25 M.

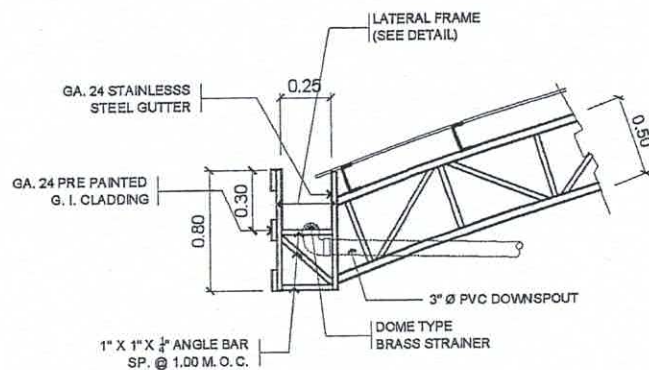


DETAIL "B"
 SCALE 1: 25 M.

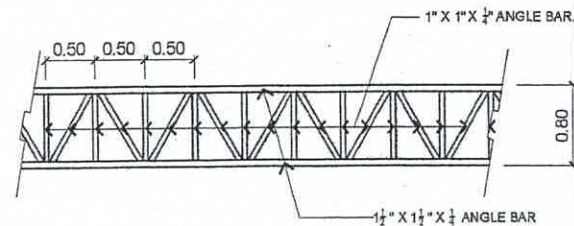

LATERAL FRAME
 OF GUTTER

PREPARED BY: E. N. RODEROS JR. PPU CEIT		END USER: D. L. ESPINELI DEAN SILANG CAMPUS		ENDORSED BY: R. V. NUESTRO DEAN CEIT		REC. APPROVAL: H. D. ROBLES VPASS CVSU		APPROVED BY: D. C. CHAVEZ PRES CVSU		PROJECT TITLE/LOCATION: PROPOSED STAGE CVSU, SILANG CAMPUS		IMPLEMENTING AGENCY: CAVITE STATE UNIVERSITY	SHT NO: S - 5
---	--	---	--	--	--	--	--	---	--	--	--	---	------------------

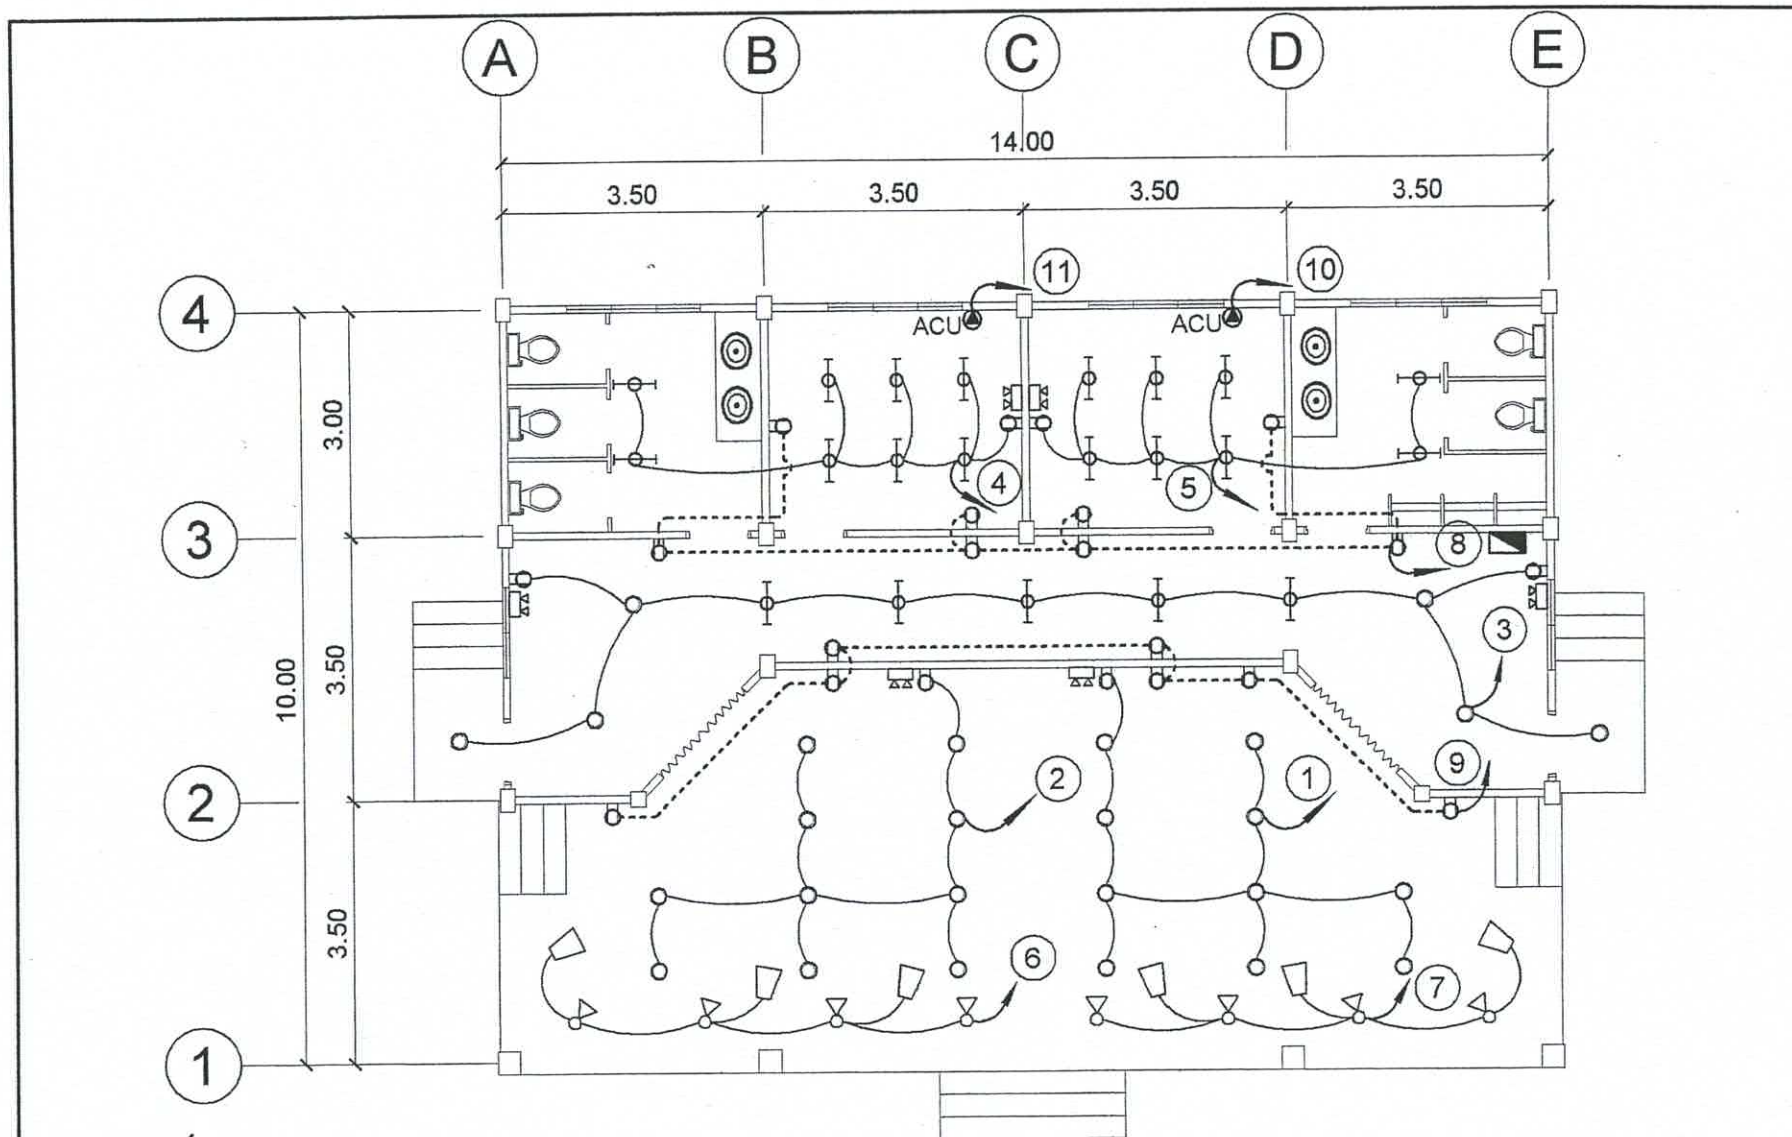

ELECTRICAL LAYOUT

SCALE

1 : 100 MTS.

CADD DRAWN BY:

E. N. RODEROS JR.
PPIJ

ELECTL. ENGR:

RONALD P. PEÑA

END USER:

D. L. ESPINELI
DEAN
SLANG CAMPUS

ENDORSED BY:

R. V. NUESTRO
DEAN
CEIT

REC. APPROVAL:

H. D. ROBLES
VPASS
CVSU

APPROVED BY:

D. C. CHAVEZ
PRES
CVSU

PROJECT TITLE/LOCATION:

PROPOSED STAGE
CVSU, SLANG CAMPUS

IMPLEMENTING AGENCY:

CAVITE STATE UNIVERSITY

SHT NO:

E - 1

SCHEDULE OF LOADS

PANEL: LIGHT AND POWER PANEL -LPP

1 - Phase 2- Wire + Ground 230 volts surface mounted

Circuit No.	No. of Outlets	Load Description					Rating of Load					Size of Conductor		Size Of Conduit	Circuit Protection				
			S1	S2	S3	S3 w	HP	Ø	Volts	Amp	Watts	MM2 THHN	MM2 THHN (G)	In MM Ø	AT	AF	POLE	Type	
1	11	LIGHTING OUTLET						1	230	4.78	1100	2 - 2.0		20	15	100	2	B - ON	
2	11	LIGHTING OUTLET						1	230	4.78	1100	2 - 2.0		20	15	100	2	B - ON	
3	12	LIGHTING OUTLET						1	230	5.22	1200	2 - 2.0		20	15	100	2	B - ON	
4	9	LIGHTING OUTLET						1	230	3.91	900	2 - 2.0		20	15	100	2	B - ON	
5	9	LIGHTING OUTLET						1	230	3.91	900	2 - 2.0		20	15	100	2	B - ON	
6	7	LIGHTING OUTLET						1	230	4.57	1050	2 - 2.0		20	15	100	2	B - ON	
7	7	LIGHTING OUTLET						1	230	4.57	1050	2 - 2.0		20	15	100	2	B - ON	
8	7	CONV.OUTLET						1	230	3.04	700	2 - 3.5		20	20	100	2	B - ON	
9	8	CONV.OUTLET						1	230	3.48	800	2 - 3.5		20	20	100	2	B - ON	
10	1	RACU					1	1	230	6.52	1500	2 - 3.5	+	1 - 2.0	20	20	100	2	B - ON
11	1	RACU					1	1	230	6.52	1500	2 - 3.5	+	1 - 2.0	20	20	100	2	B - ON
12		SPARE																	
		TOTAL						1	230		11800	2 - 14.0 THW	+	1 - 3.5 THW	30	70	100	2	B - ON

FEEDER and CURRENT PROTECTION COMPUTATION:

$$I_{FL} = \frac{[(11800 + (0.25 \times 1500))] \times 0.80}{230} = 42.35 \text{ amperes}$$

USE:

MAIN : 70 AT, 100AF, 240V, 2P CB with solid neutral
FEEDER: 2- 14.0 SQ. MM THW + 1 - 3.5 SQ MM THW (G) in 30 MM dia CONDUIT

CADD DRAWN BY:

E. N. RODEROS JR.
PPU

ELECT. ENGR:

RONALD P. PEÑA

END USER:

D. L. ESPINELI
DEAN
SILANG CAMPUS

ENDORSEMENT:

R. V. NUESTRO
DEAN
CEIT

REC. APPROVAL:

H. D. ROBLES
VPASS
CVSU

APPROVED BY:

D. C. CHAVEZ
PRES
CVSU

PROJECT TITLE/LOCATION:


PROPOSED STAGE
CVSU, SILANG CAMPUS

IMPLEMENTING AGENCY:

CAVITE STATE UNIVERSITY

SHT NO:

E - 2

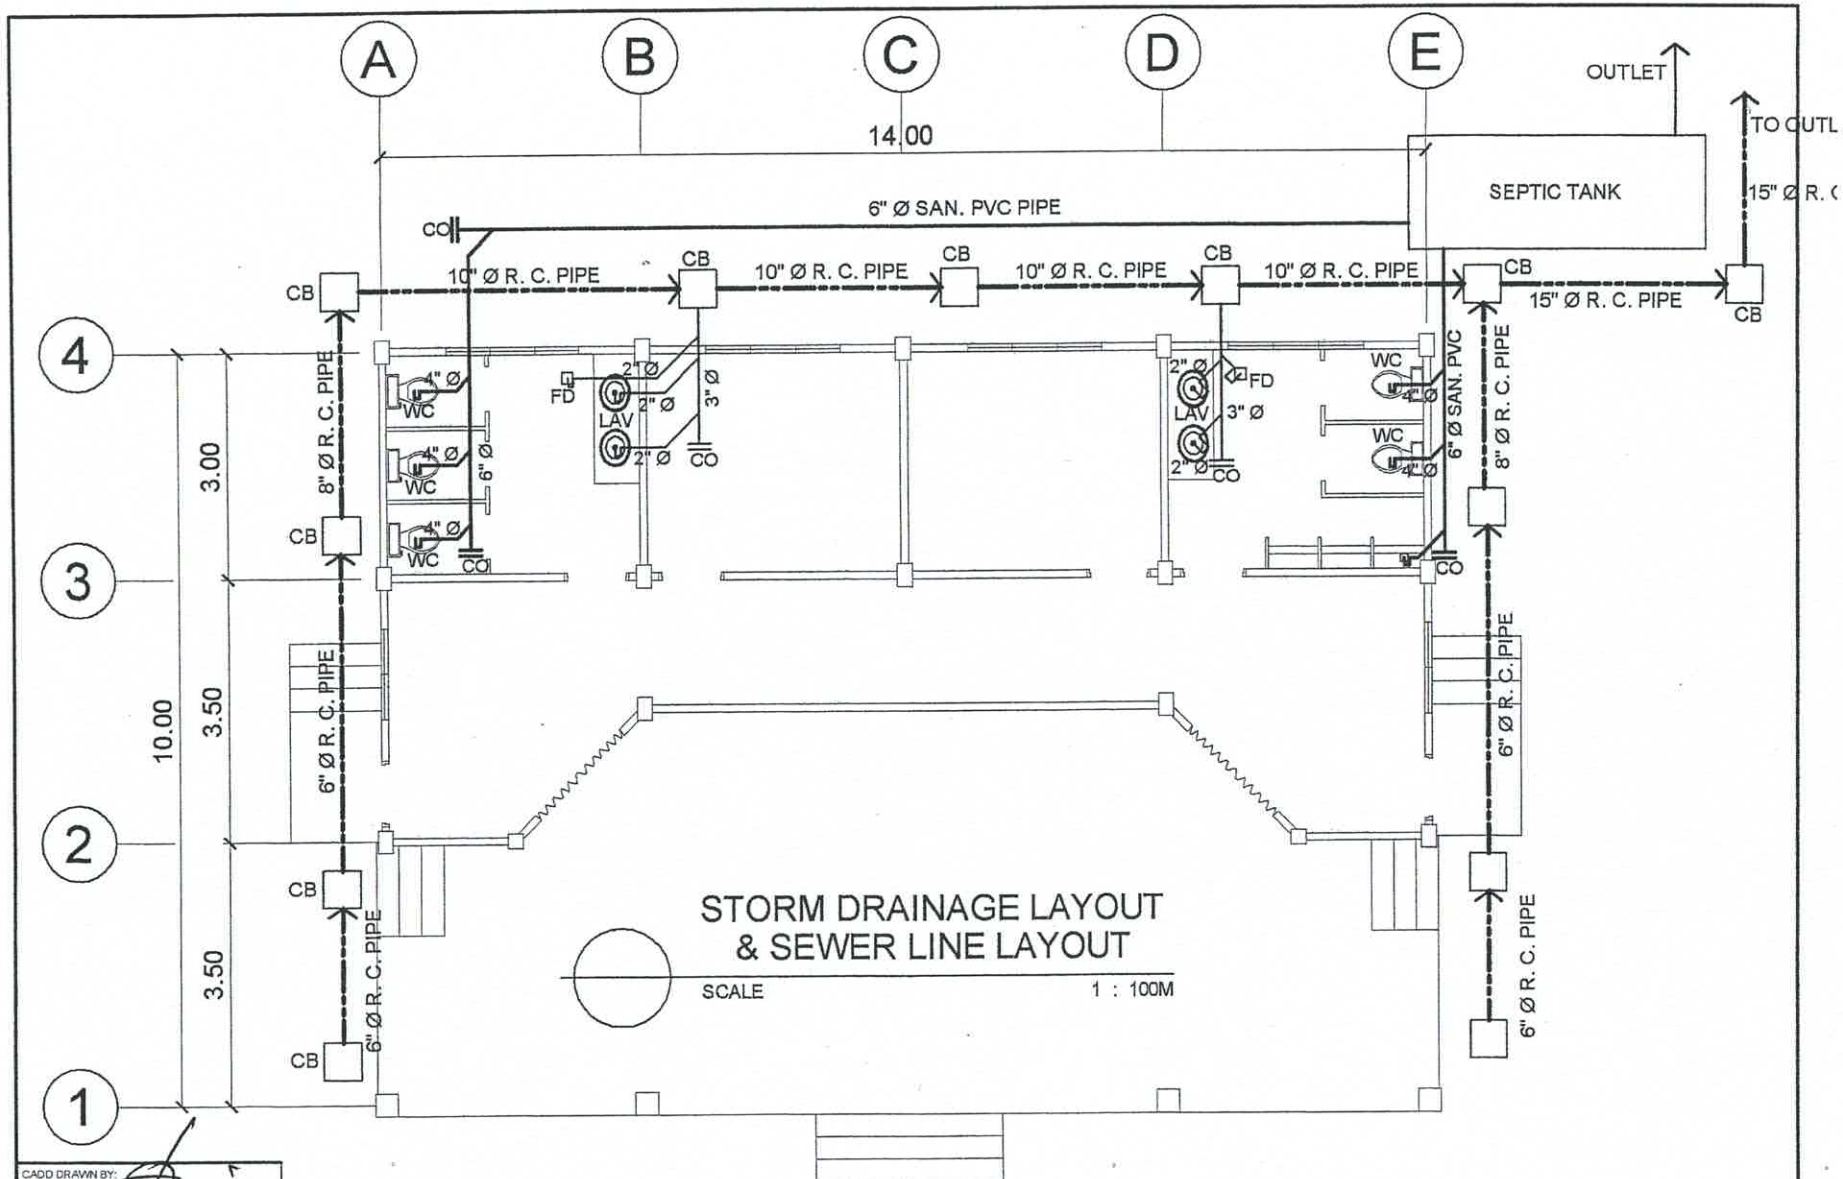

CADD DRAWN BY:
E. N. RODEROS JR.
 PPU

MASTER PLUMBER:
S. B. BAYOT JR.

END USER:
D. L. ESPINELI
 DEAN
 SILANG CAMPUS

ENDORSE:
R. V. NUESTRO
 DEAN
 CEIT


REC. APPROVAL:
H. D. ROBLES
 VPASS
 CVSU

APPROVED BY:
D. C. CHAVEZ
 PRES
 CVSU

PROJECT TITLE/LOCATION:
PROPOSED STAGE
 CVSU, SILANG CAMPUS

IMPLEMENTING AGENCY:
CAVITE STATE UNIVERSITY

SHT NO:
P - 1

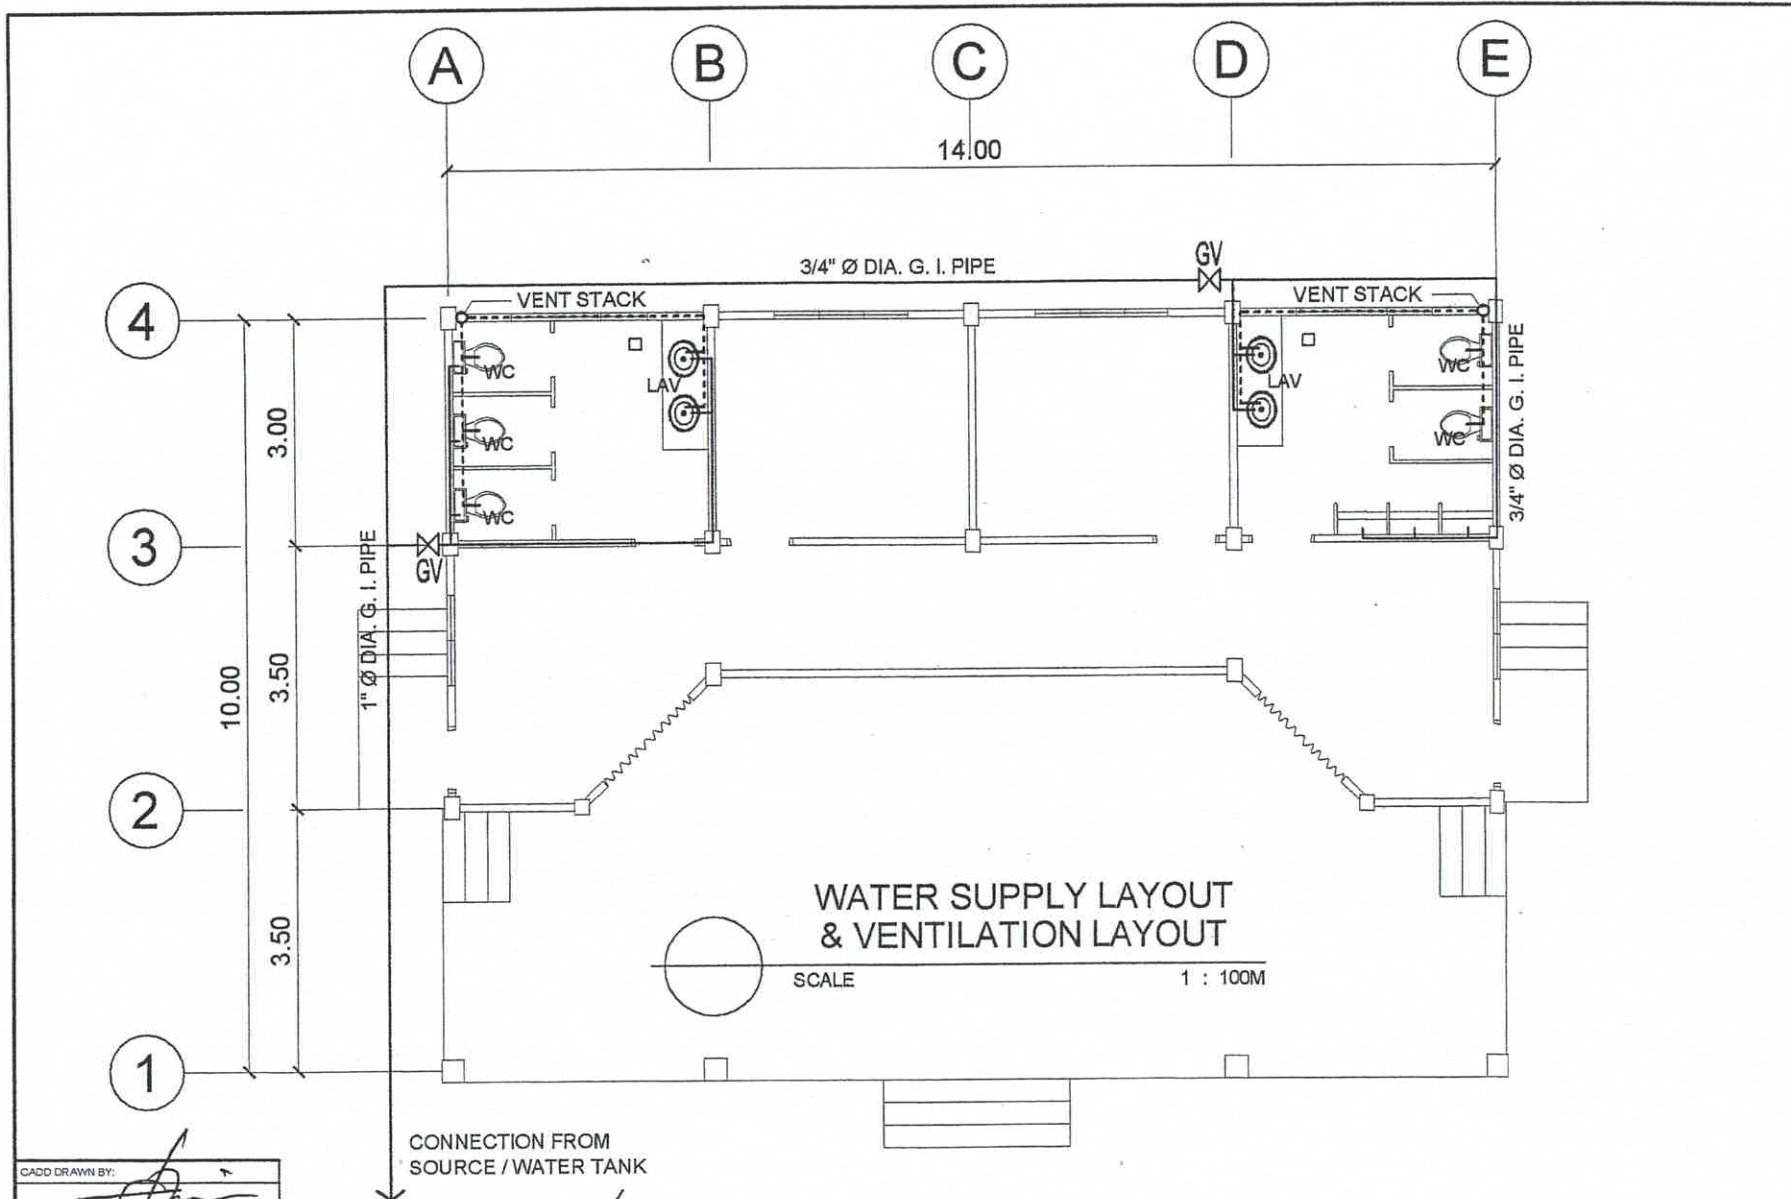

CADD DRAWN BY:
E. N. RODRIGOS JR.
 PPU CEIT

MASTER PLUMBER:
S. B. BAYOT JR.

END USER:
D. L. ESPINELI
 DEAN SILANG CAMPUS

ENDORSE BY:
R. V. NUESTRO
 DEAN CEIT


REC. APPROVAL:
H. D. ROBLES
 VPASS CVSU

APPROVED BY:
D. C. CHAVEZ
 PRES CVSU


PROJECT TITLE/LOCATION:
PROPOSED STAGE
 CVSU, SILANG CAMPUS

IMPLEMENTING AGENCY:
CAVITE STATE UNIVERSITY

SHT NO:
P - 2

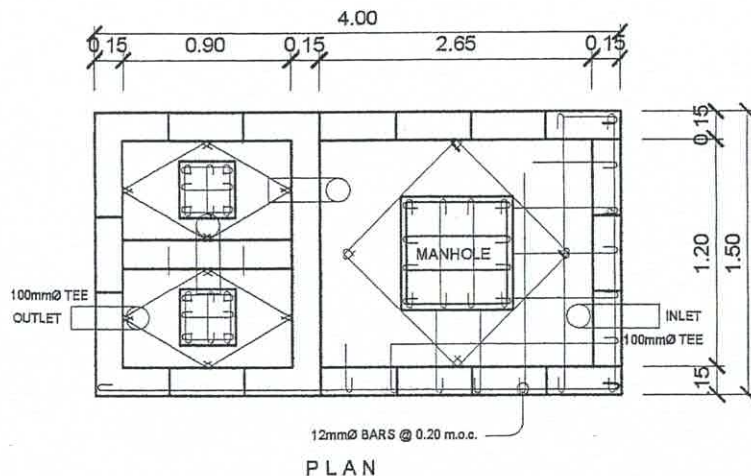


PLAN

 


DETAIL OF SEPTIC TANK

SCALE


N.T.S.

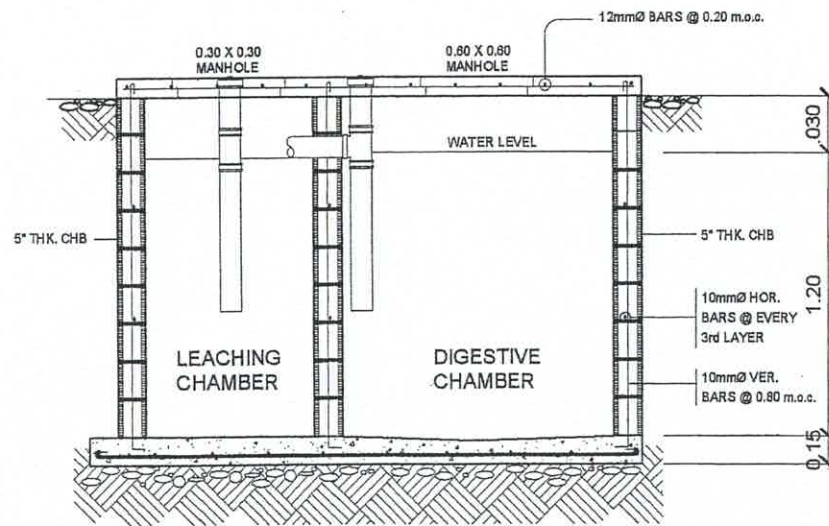


SECTION

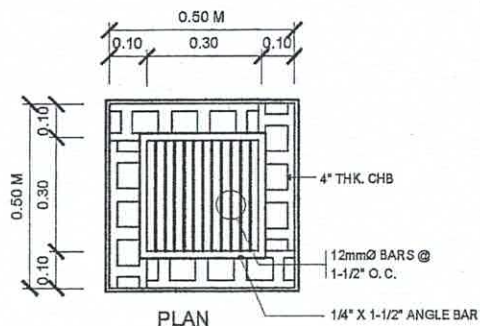

PLAN

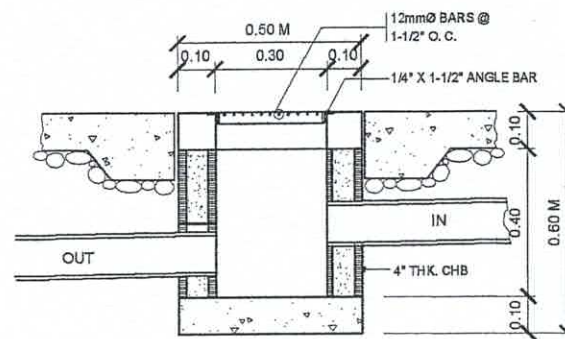

SECTION

 

DETAIL OF CATCH BASIN

SCALE

1 : 20M

CADD DRAWN BY: <i>[Signature]</i>	END USER: <i>[Signature]</i>	ENDORSED BY: <i>[Signature]</i>	REC. APPROVAL: <i>[Signature]</i>	APPROVED BY: <i>[Signature]</i>	PROJECT TITLE/LOCATION:	IMPLEMENTING AGENCY:	SHT NO:
E. N. RODEROS JR. PPU CEIT	D. L. ESPINELI DEAN SLANG CAMPUS	R. V. NUESTRO DEAN CEIT	H. D. ROBLES VPASS CVSU	D. C. CHAVEZ PRES CVSU	PROPOSED STAGE CVSU, SLANG CAMPUS	CAVITE STATE UNIVERSITY	P - 3