


GROUND FLOOR LIGHTING LAYOUT
SCALE 1 : 100 MTS.

BID BULLETIN


CONSTRUCTION OF CVMBS ACADEMIC BUILDING

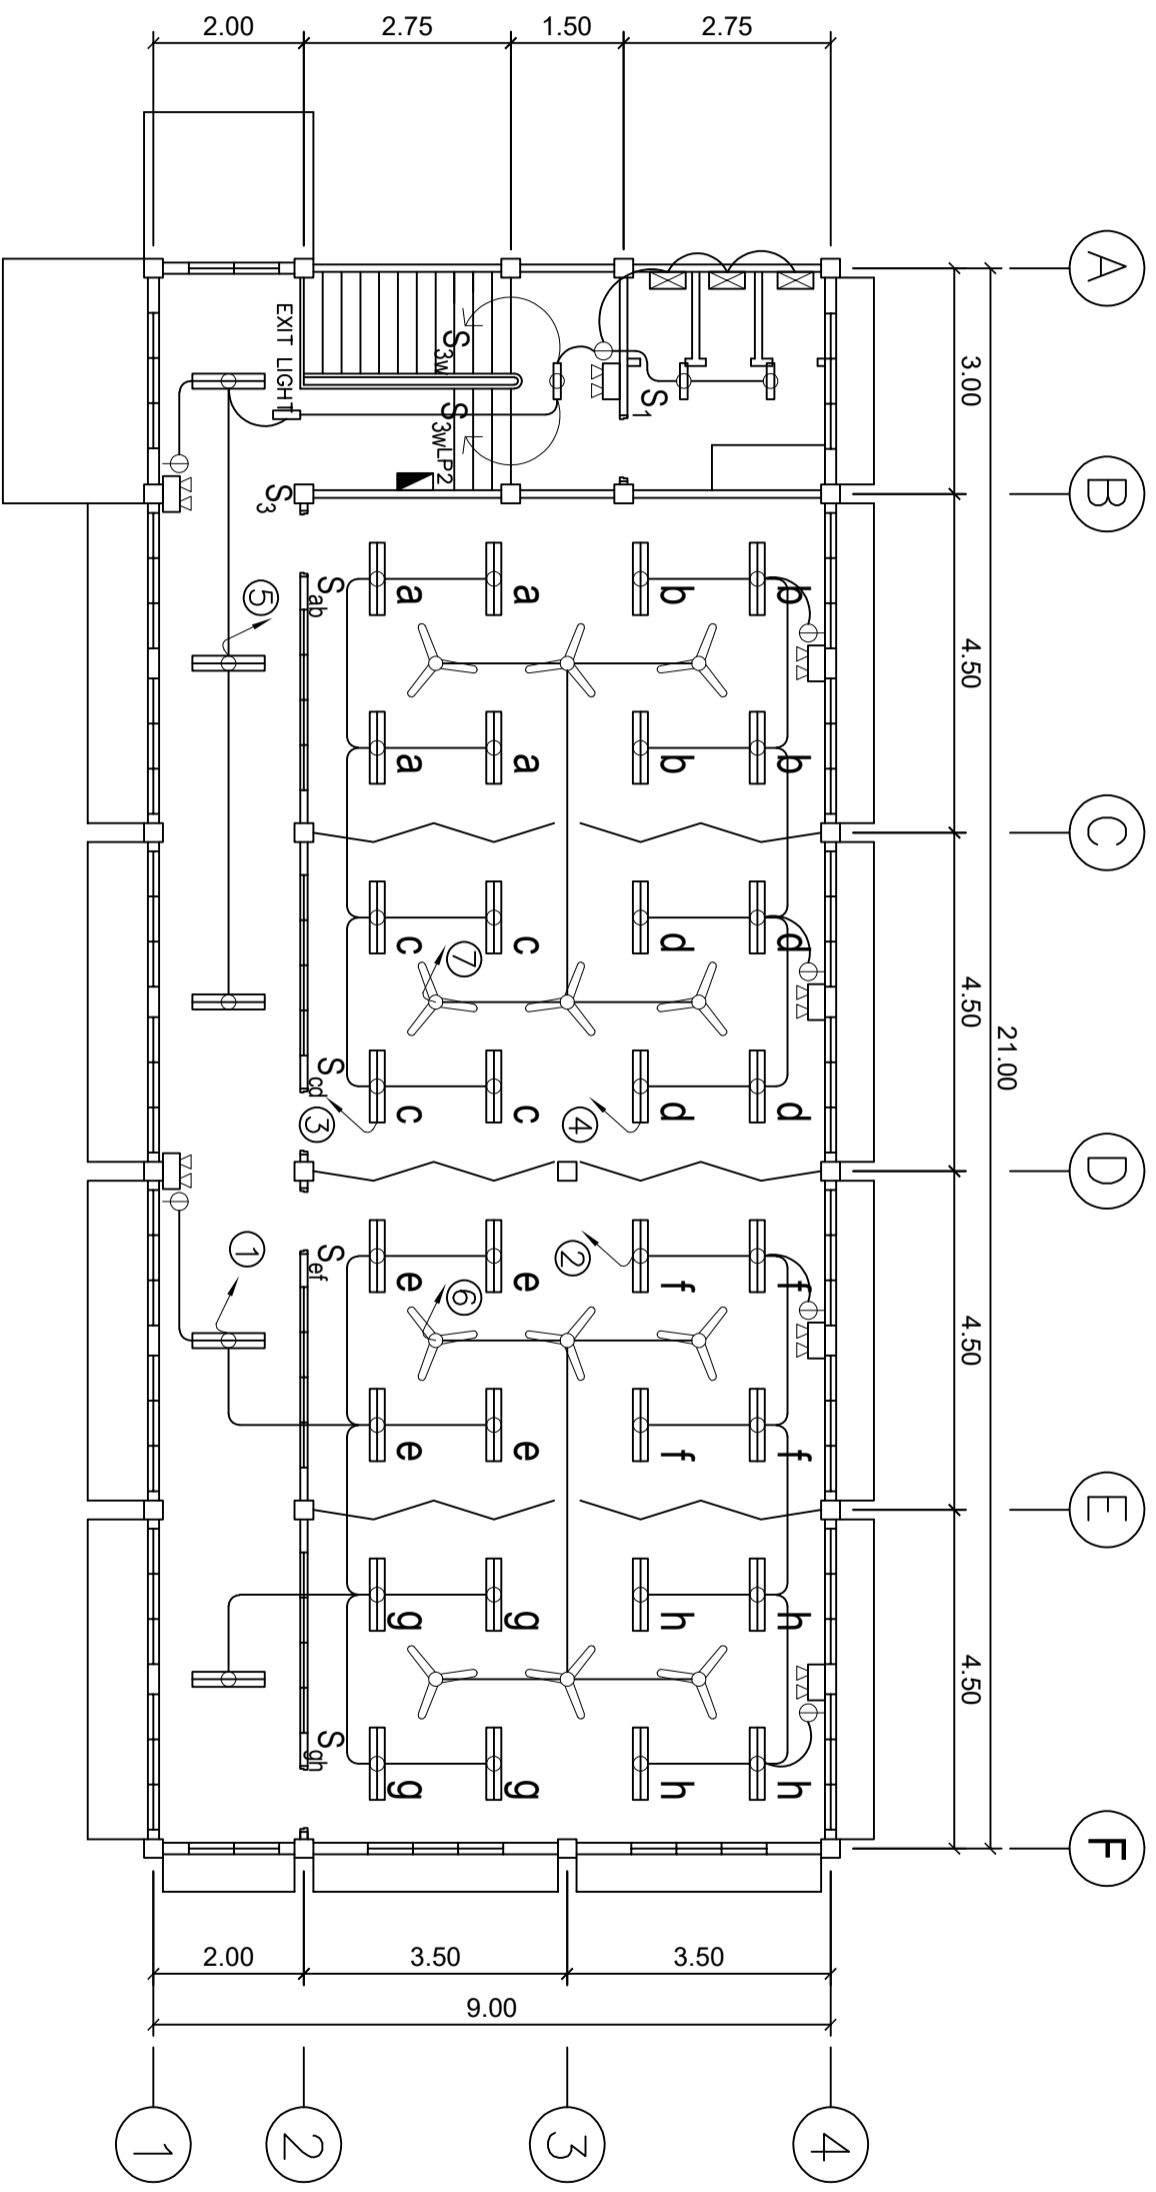

SECOND FLOOR LIGHTING LAYOUT
SCALE 1 : 100 MTS.

BID BULLETIN

CONSTRUCTION OF CVMBS ACADEMIC BUILDING

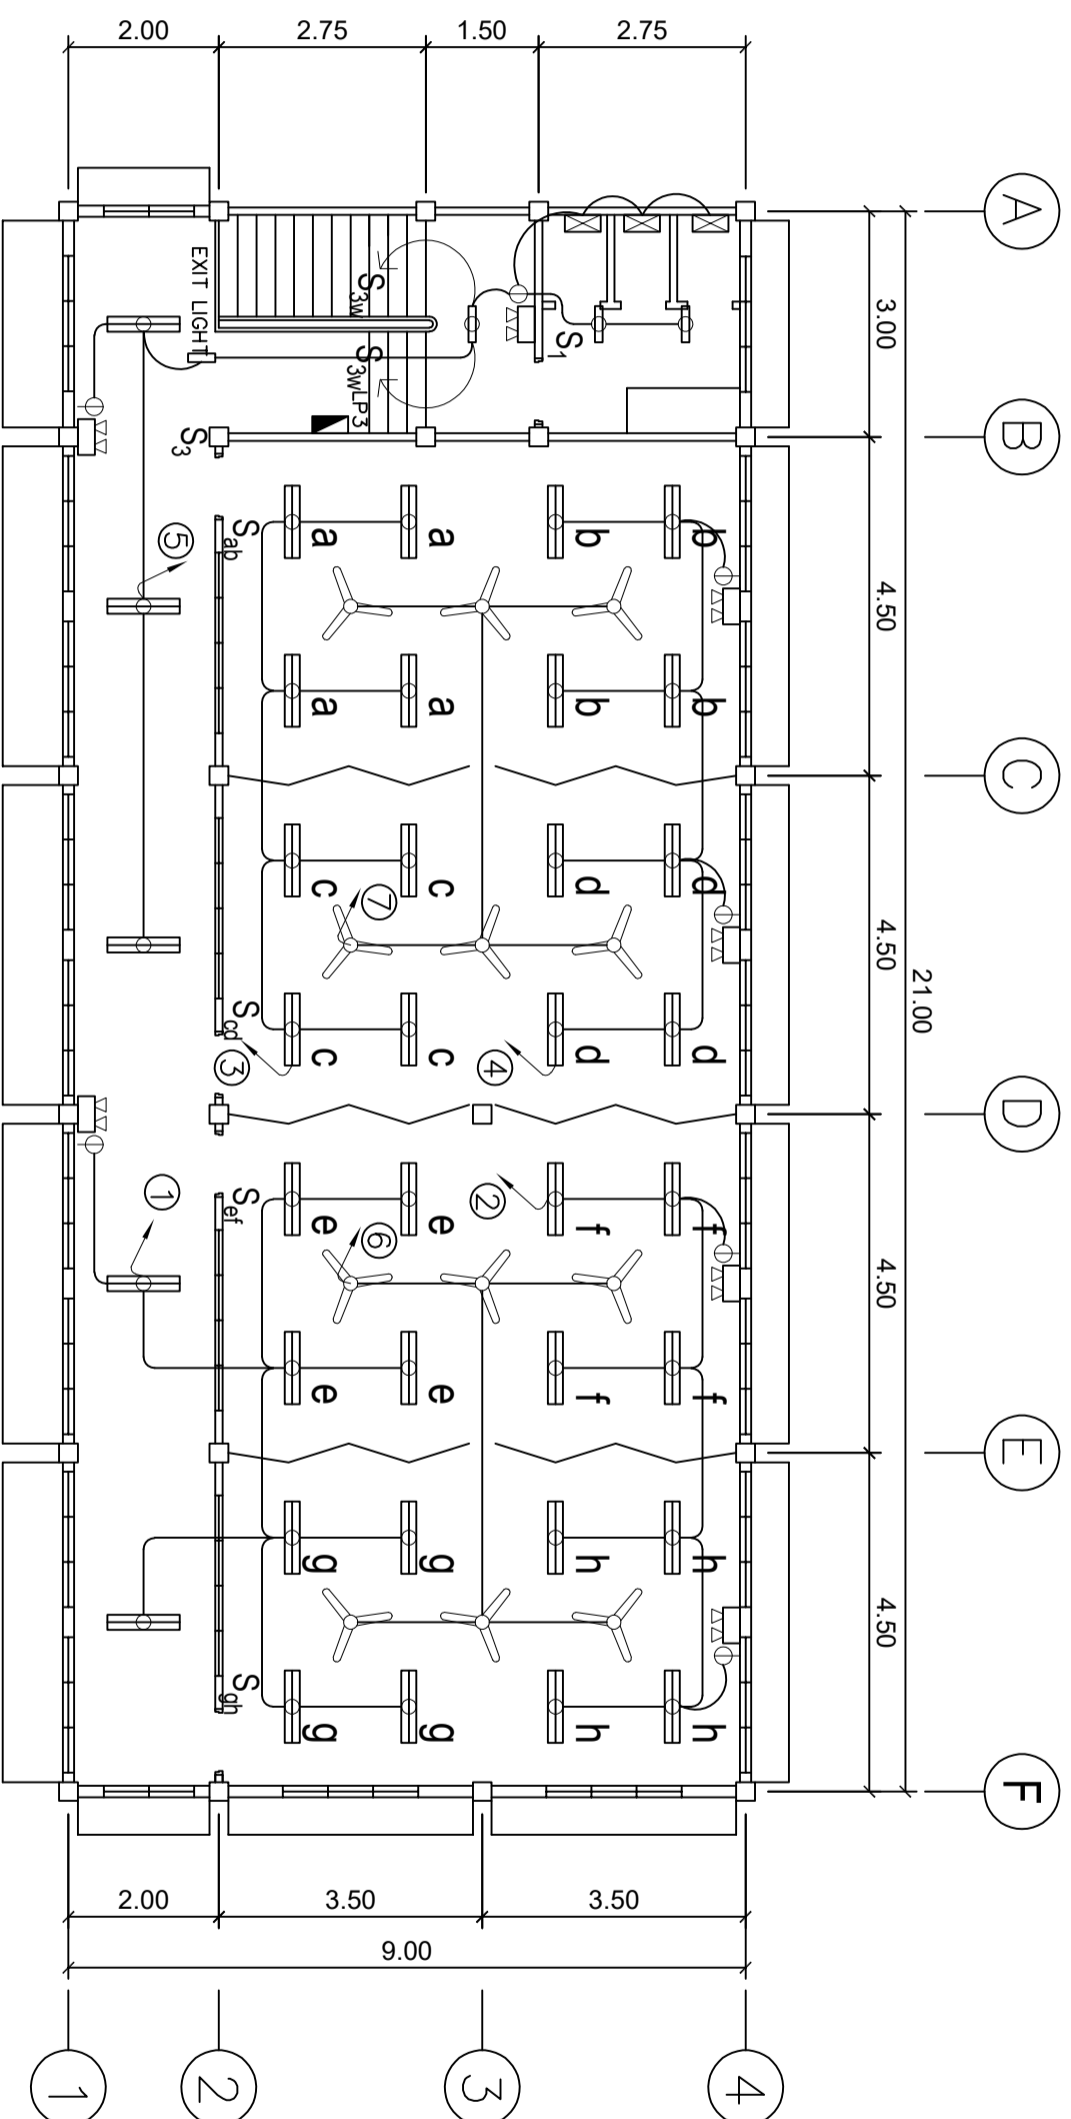


THIRD FLOOR LIGHTING LAYOUT
 SCALE 1 : 100 MTS.

BID BULLETIN

CONSTRUCTION OF CVMBS ACADEMIC BUILDING


LEGEND AND SYMBOL:	
○	STEEL POST, SCHEDULE 40, 4"
—	230 V SECONDARY WIRE 3 LINE WIRE + GROUND WIRE
▢	PANEL BOARD
□	DISTRIBUTION TRANSFORMER
■	SECONDARY POST CONCRETE PEDESTAL
CP 1	CONSTRUCTION POINTS
▨	CONCRETE ENCASEMENT RACEWAY

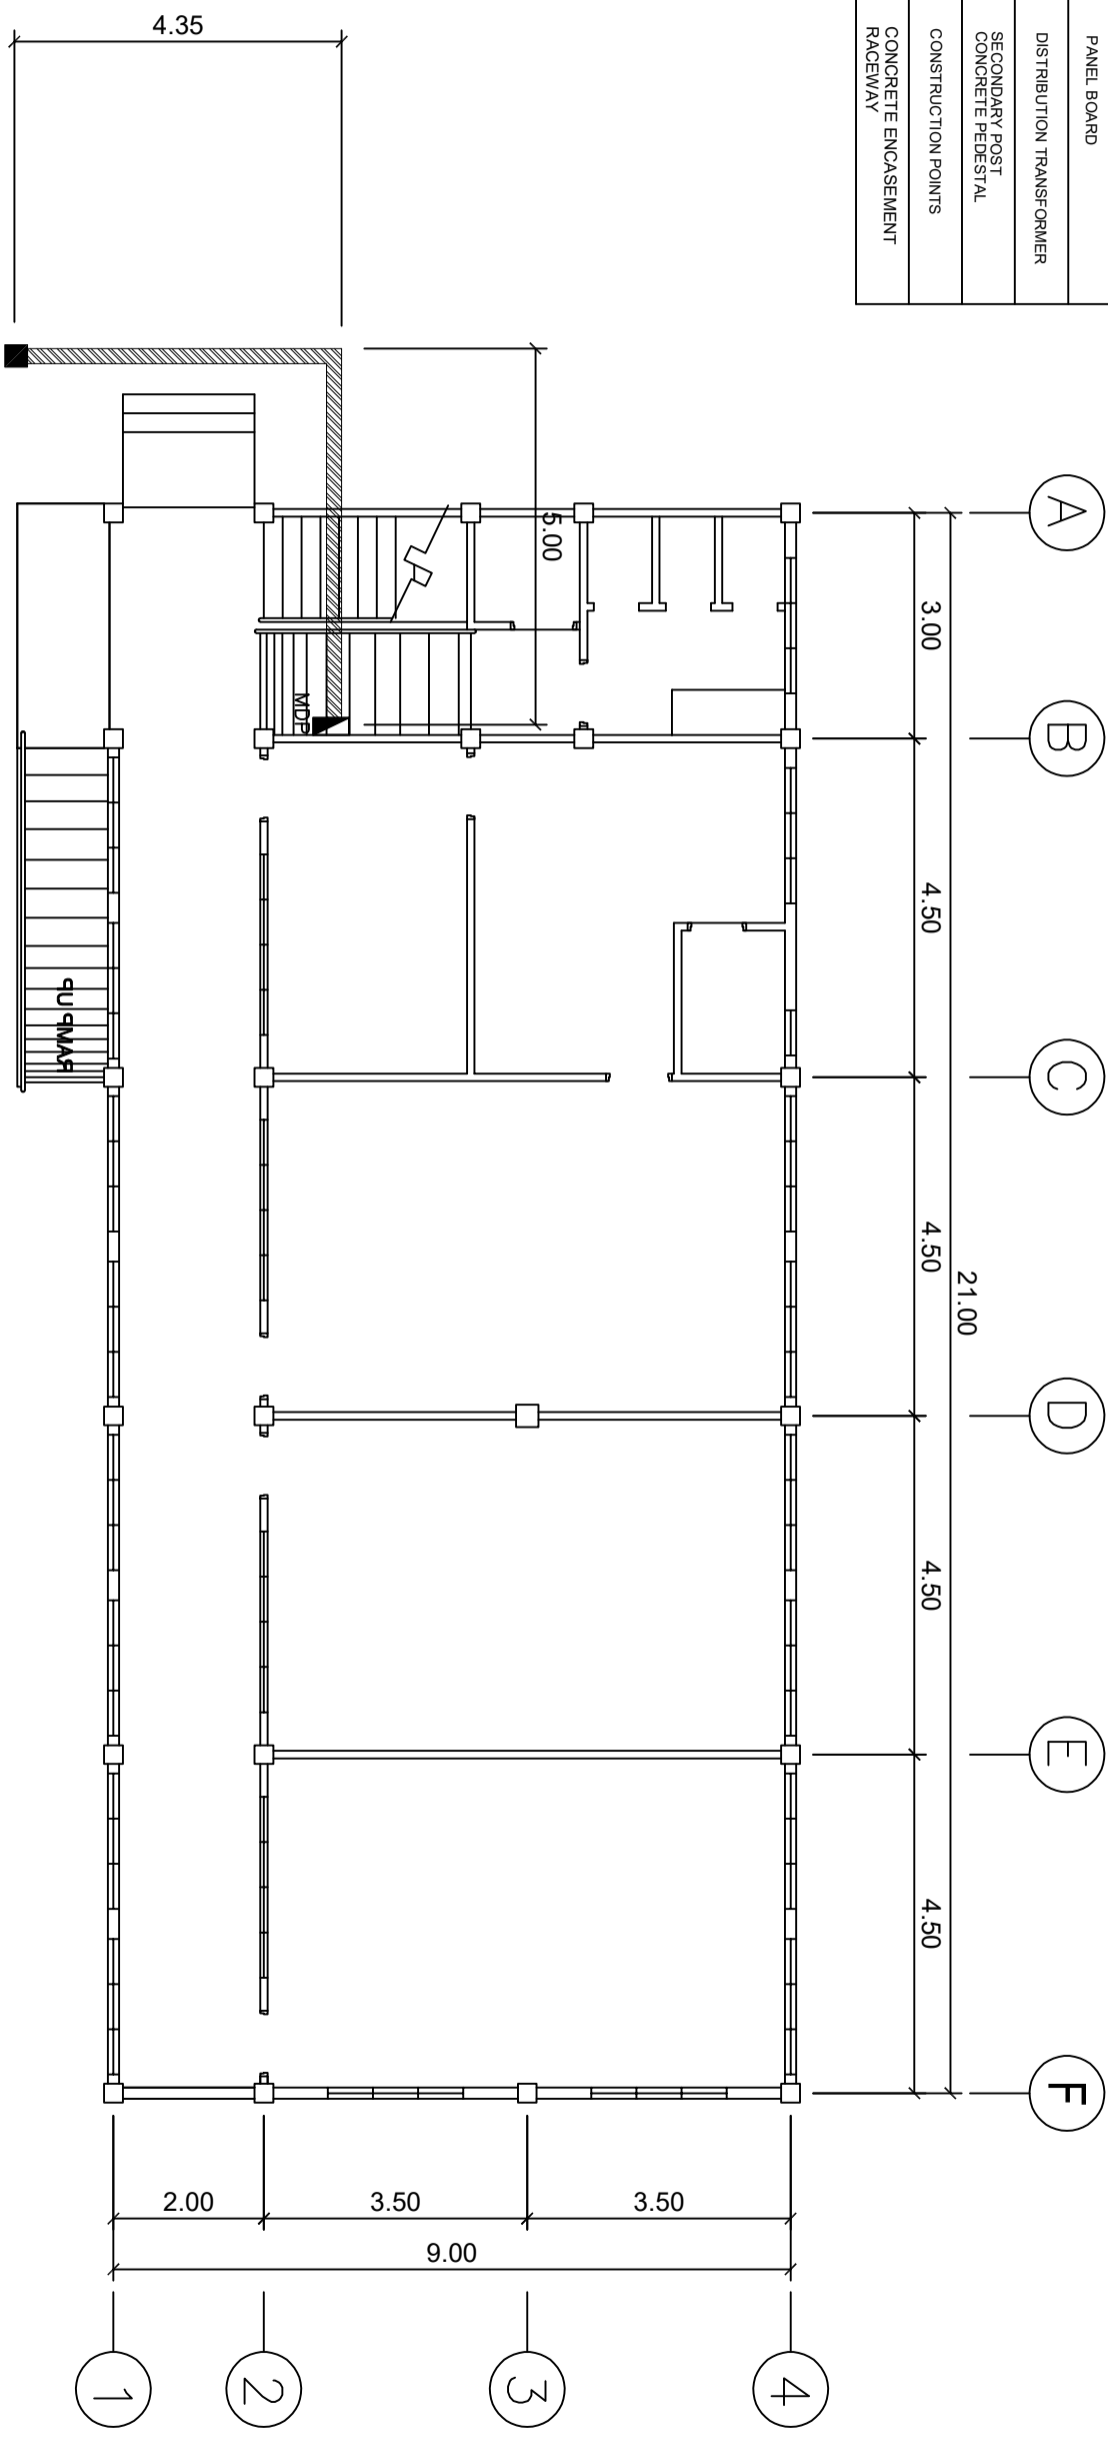

ELECTRICAL FEEDER LINE LAYOUT
SCALE 1 : 100 MTS.

BID BULLETIN



CONSTRUCTION OF CVMBS ACADEMIC BUILDING

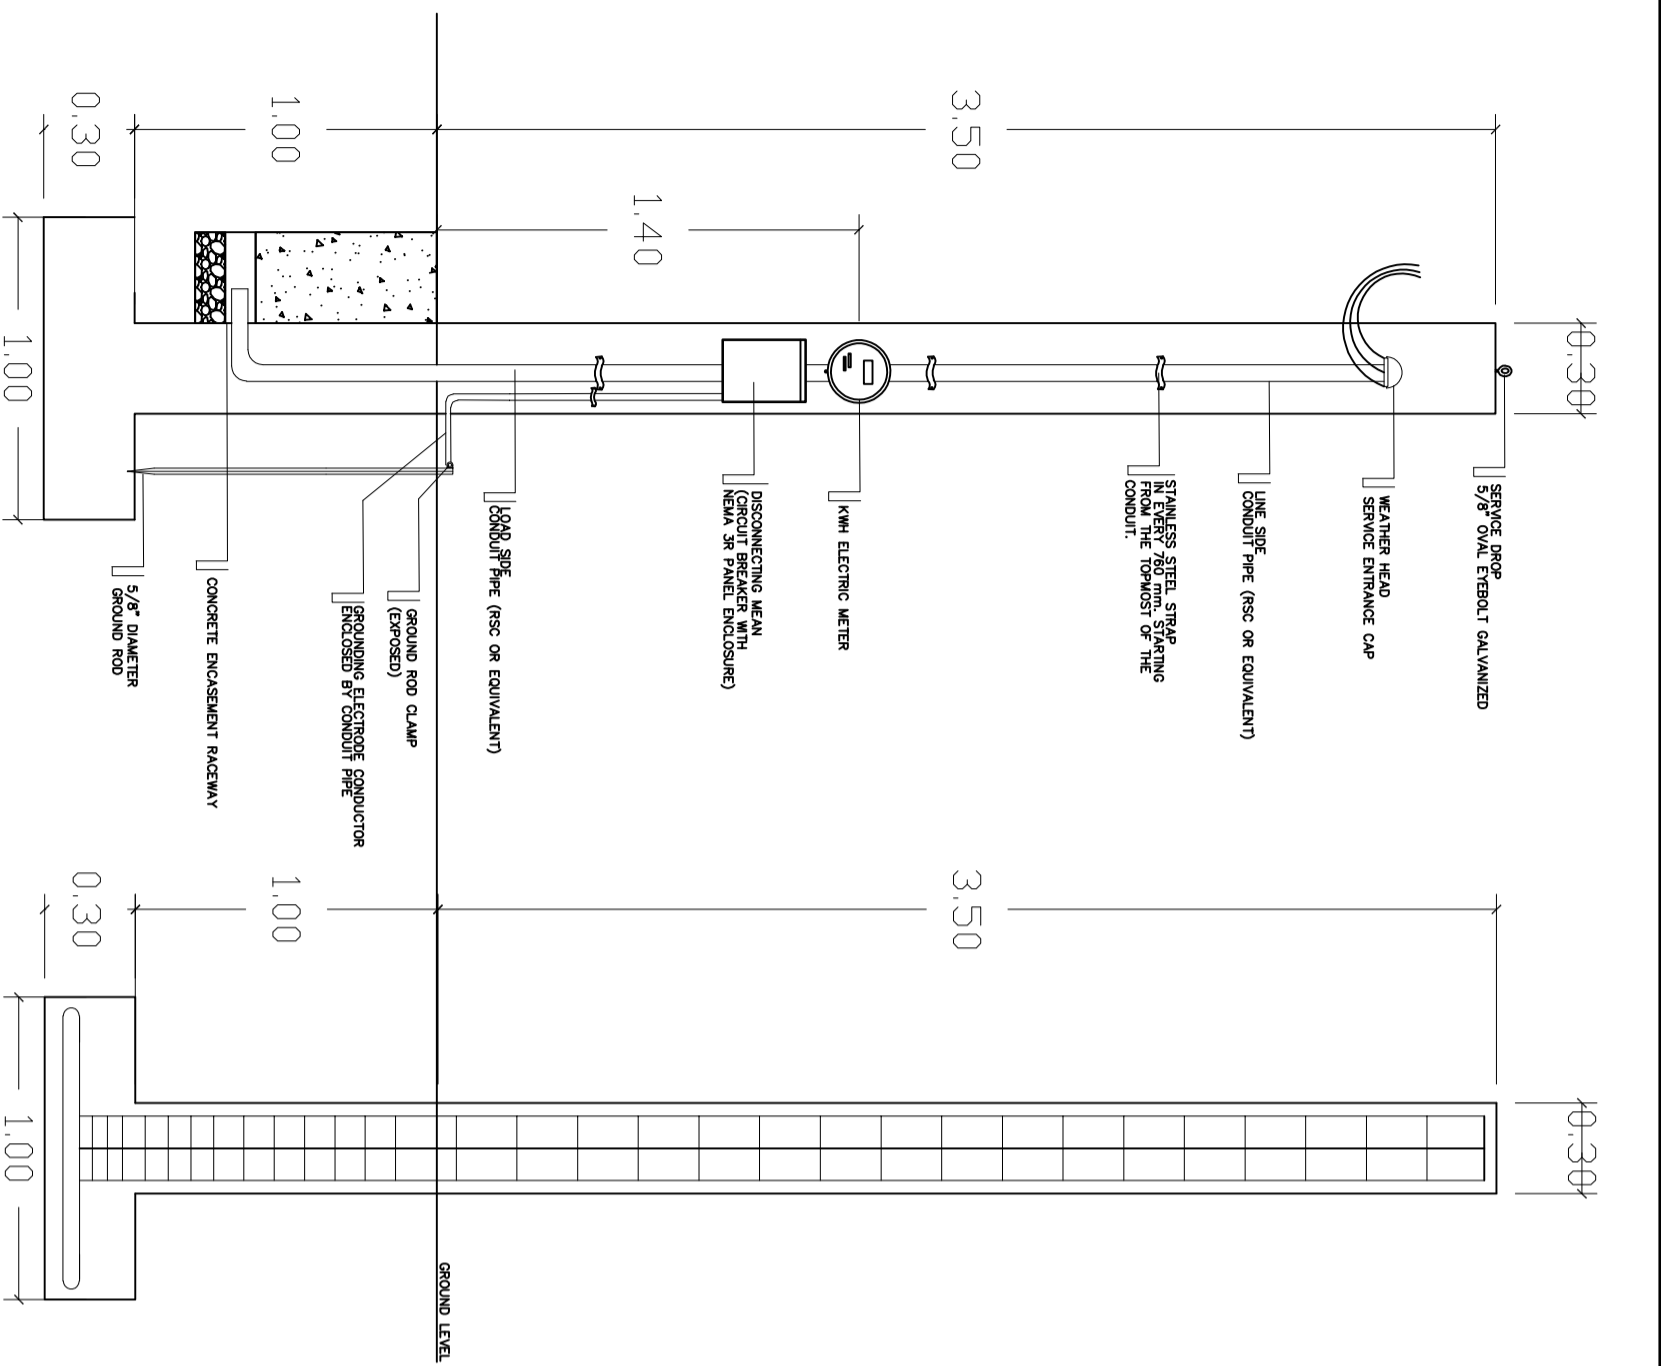

SCHEDULE OF FOOTINGS


NAME	TYPE	THICKNESS	SIZE (LxW)	DEPTH	REINFORCEMENT	
					ALONG L	ALONG W
F1	ISOLATED	300 MM	1000 x 1000 MM	1300 MM	7-16 MM Ø @ 150 MM	7-16 MM Ø @ 150 MM

COLUMN	DIMENSION	REINFORCEMENT	NO. OF TIES & SPACING
C1	300 MM X 300 MM	8 - 16mm Ø R.S.B.	2 SET OF 10mm Ø TIES @ 2-50mm, 4-75mm, 6-100mm, REST @ 200mm O.C.

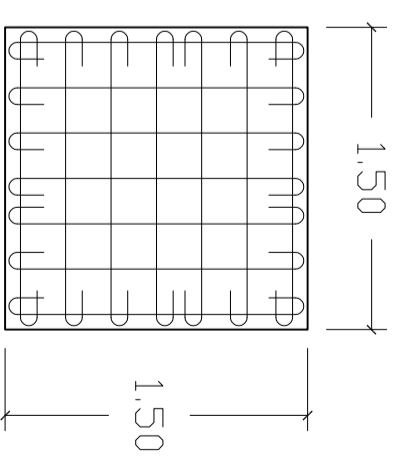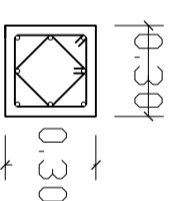

8 - 16mm Ø R.S.B.
2 SET OF 10mm Ø TIES
@ 2-50mm, 4-75mm,
6-100mm, REST @ 200mm O.C.

7-16 MM Ø
@ 150 MM

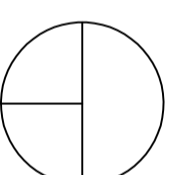

SECONDARY POST DETAILS
SCALE

1 : 25 MTS.

BID BULLETIN

CONSTRUCTION OF CVMBS ACADEMIC BUILDING